


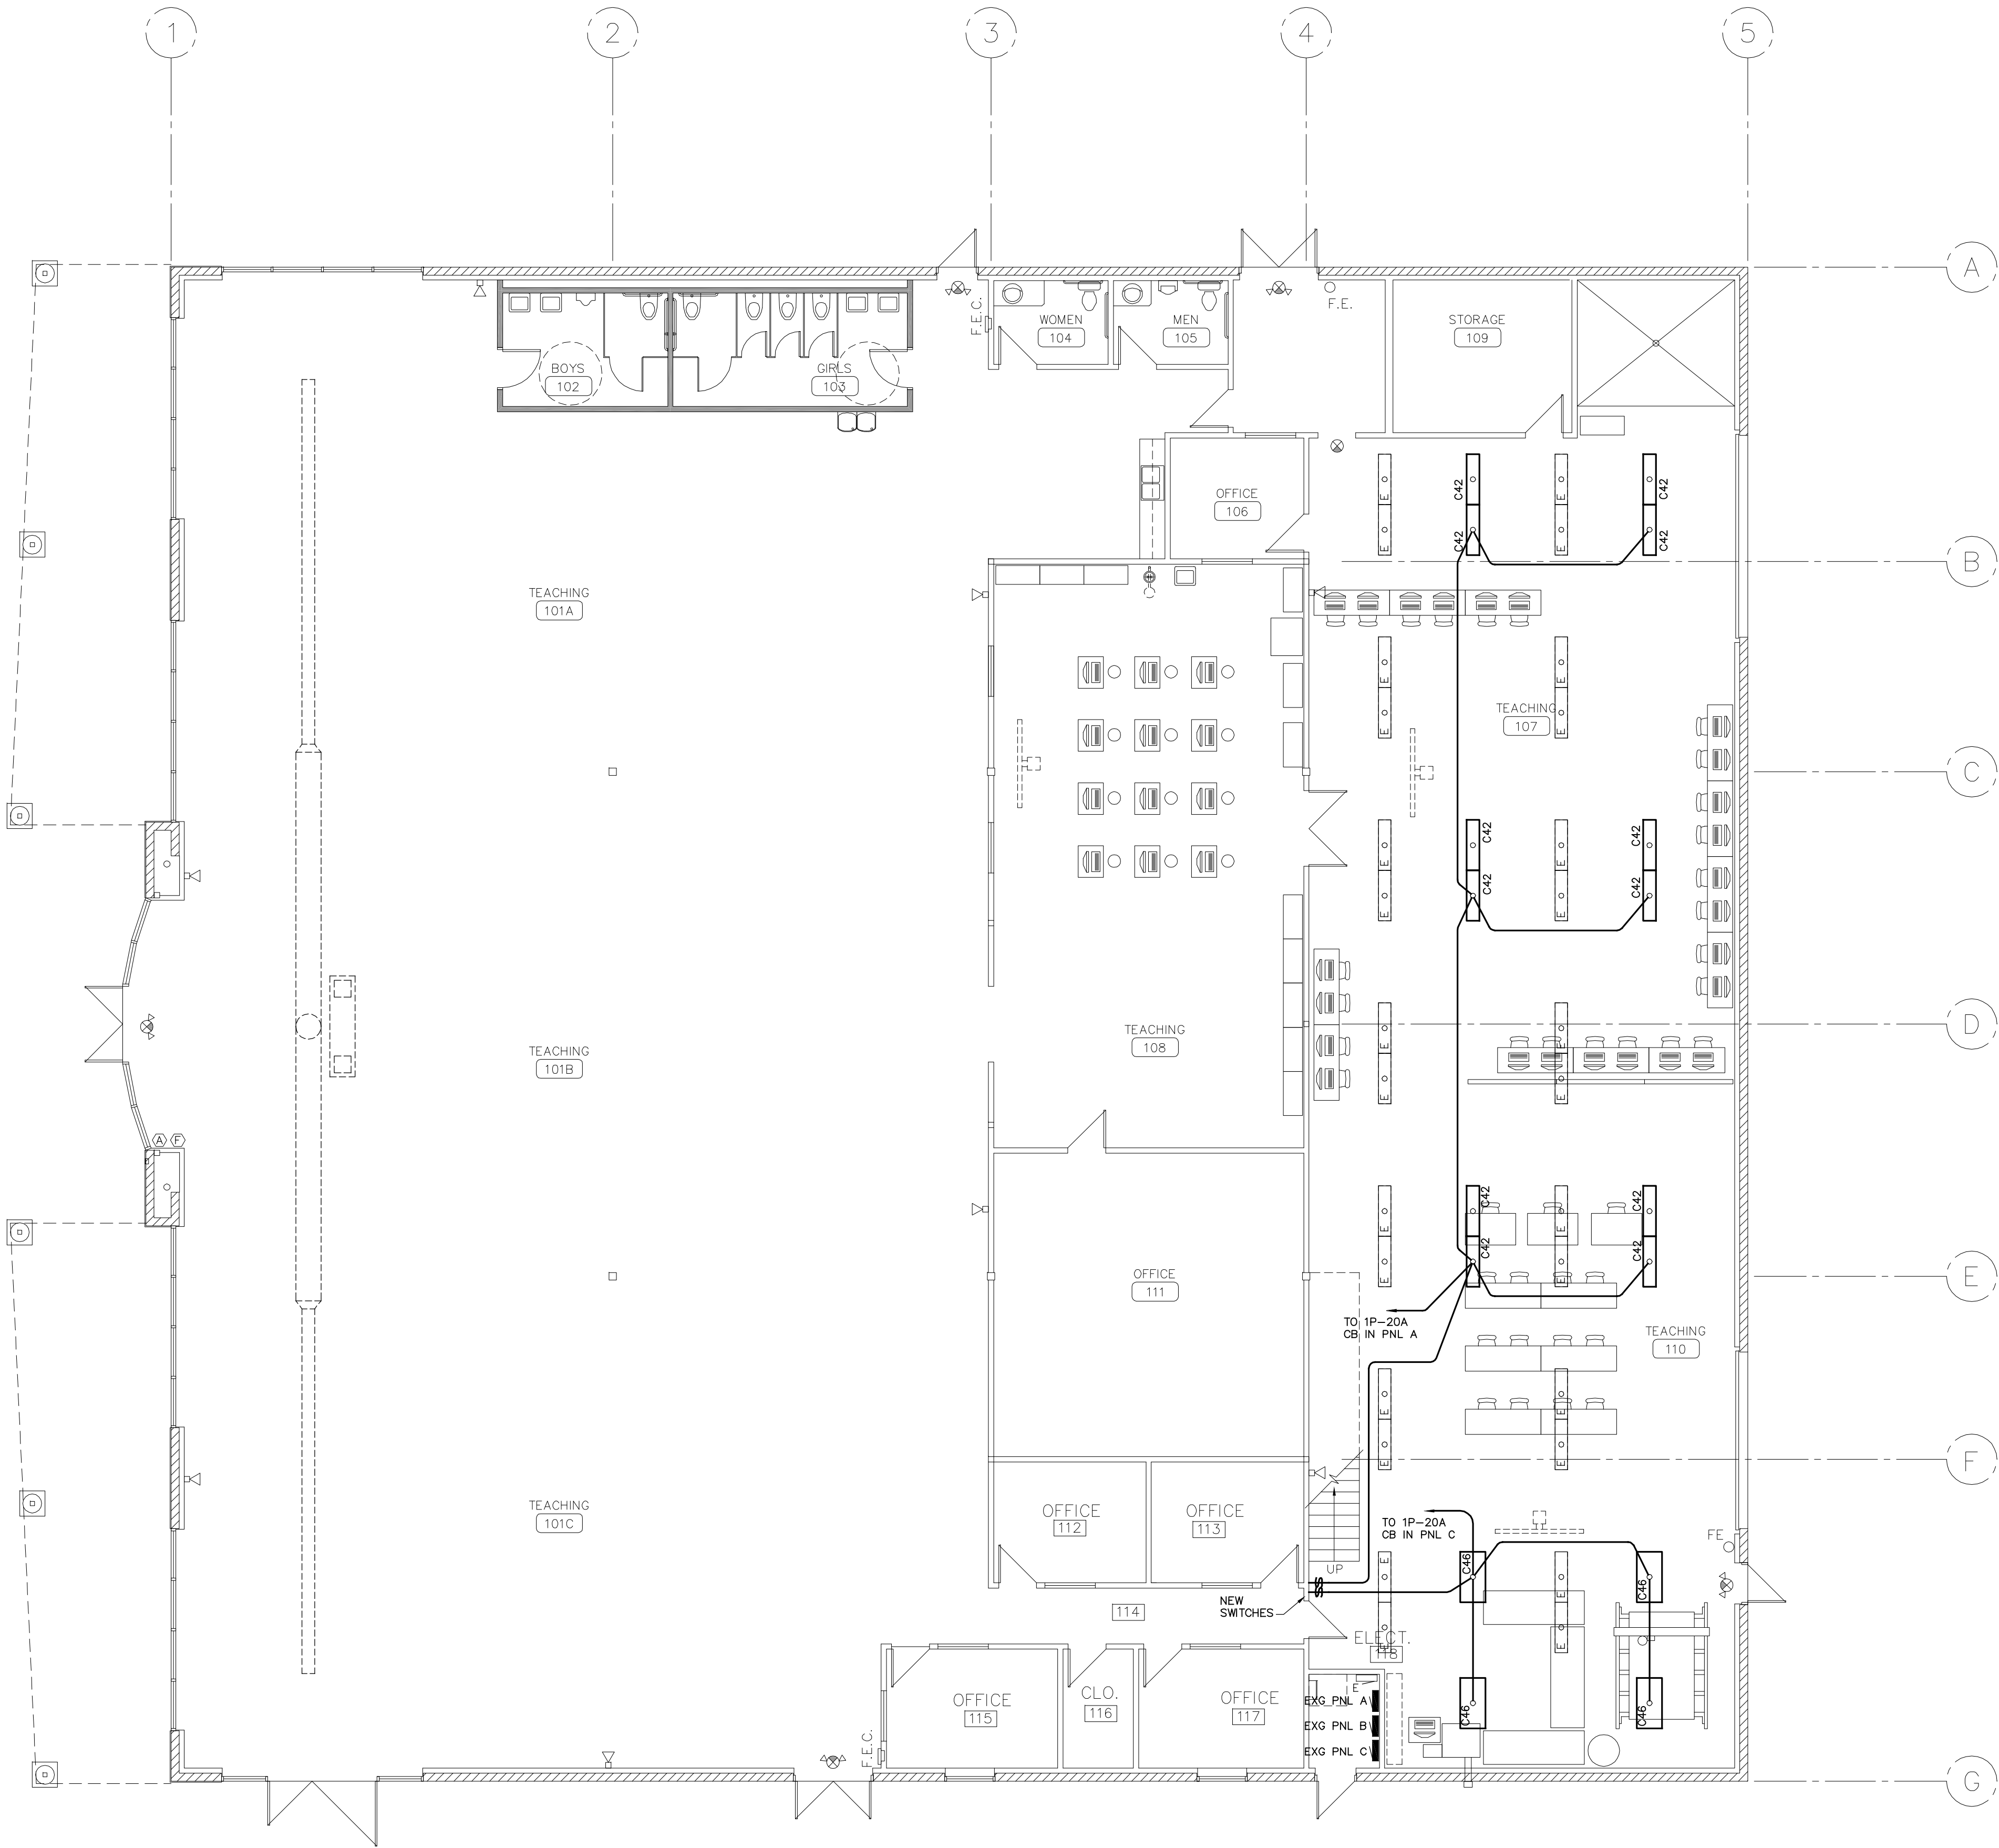

FLOOR PLAN - LIGHTING
Scale: 1/8" = 1'-0"


XFP1

LUMINAIRE SCHEDULE								
TYPE	MANUFACTURER	CATALOG NUMBER	LAMPS	BALLAST	WATTS	VA	MOUNTING	REMARKS
C42	LITHONIA METALUX DAYBRITE HUBBELL COLUMBIA	#L323-MV	(2) F32T8	(1) 2-LAMP	58	65	SURFACE	MOUNT ON BEAM
C46	LITHONIA METALUX DAYBRITE HUBBELL COLUMBIA	#FGB28-6-32-T1X20-MVOLT -2/3-GE810ISL-LP841-PAF	(6) F32T8	(2) 3-LAMP	173	192	SURFACE	MOUNT ON BEAM
E		EXISTING	(2) F32T8	(1) 2-LAMP	58	65	SURFACE	TO REMAIN

LOAD CALCULATIONS
PANEL A: 120/240VAC, 3P, 4W
3P-200A MAIN BREAKER
ADDED LOAD = 780-VA = 3.3% OF PANEL RATING

PANEL C: 120/240VAC, 3P, 4W
3P-200A MAIN BREAKER
ADDED LOAD = 768-VA = 3.2% OF PANEL RATING

REVISIONS

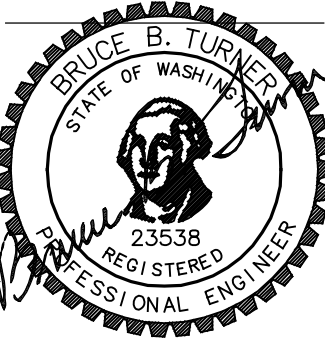

10-30-2013

MEAD SCHOOL DISTRICT NO. 354
MEAD RIVERPOINT ACADEMY
CHANGE IN OCCUPANCY
11008 N NEWPORT HIGHWAY, SPOKANE, WA

NAC | **ARCHITECTURE**

NAC NO. 111-13072
FILE E2-01
DRAWN NH
CHECKED BBT
DATE 10/30/13

E
2.1