


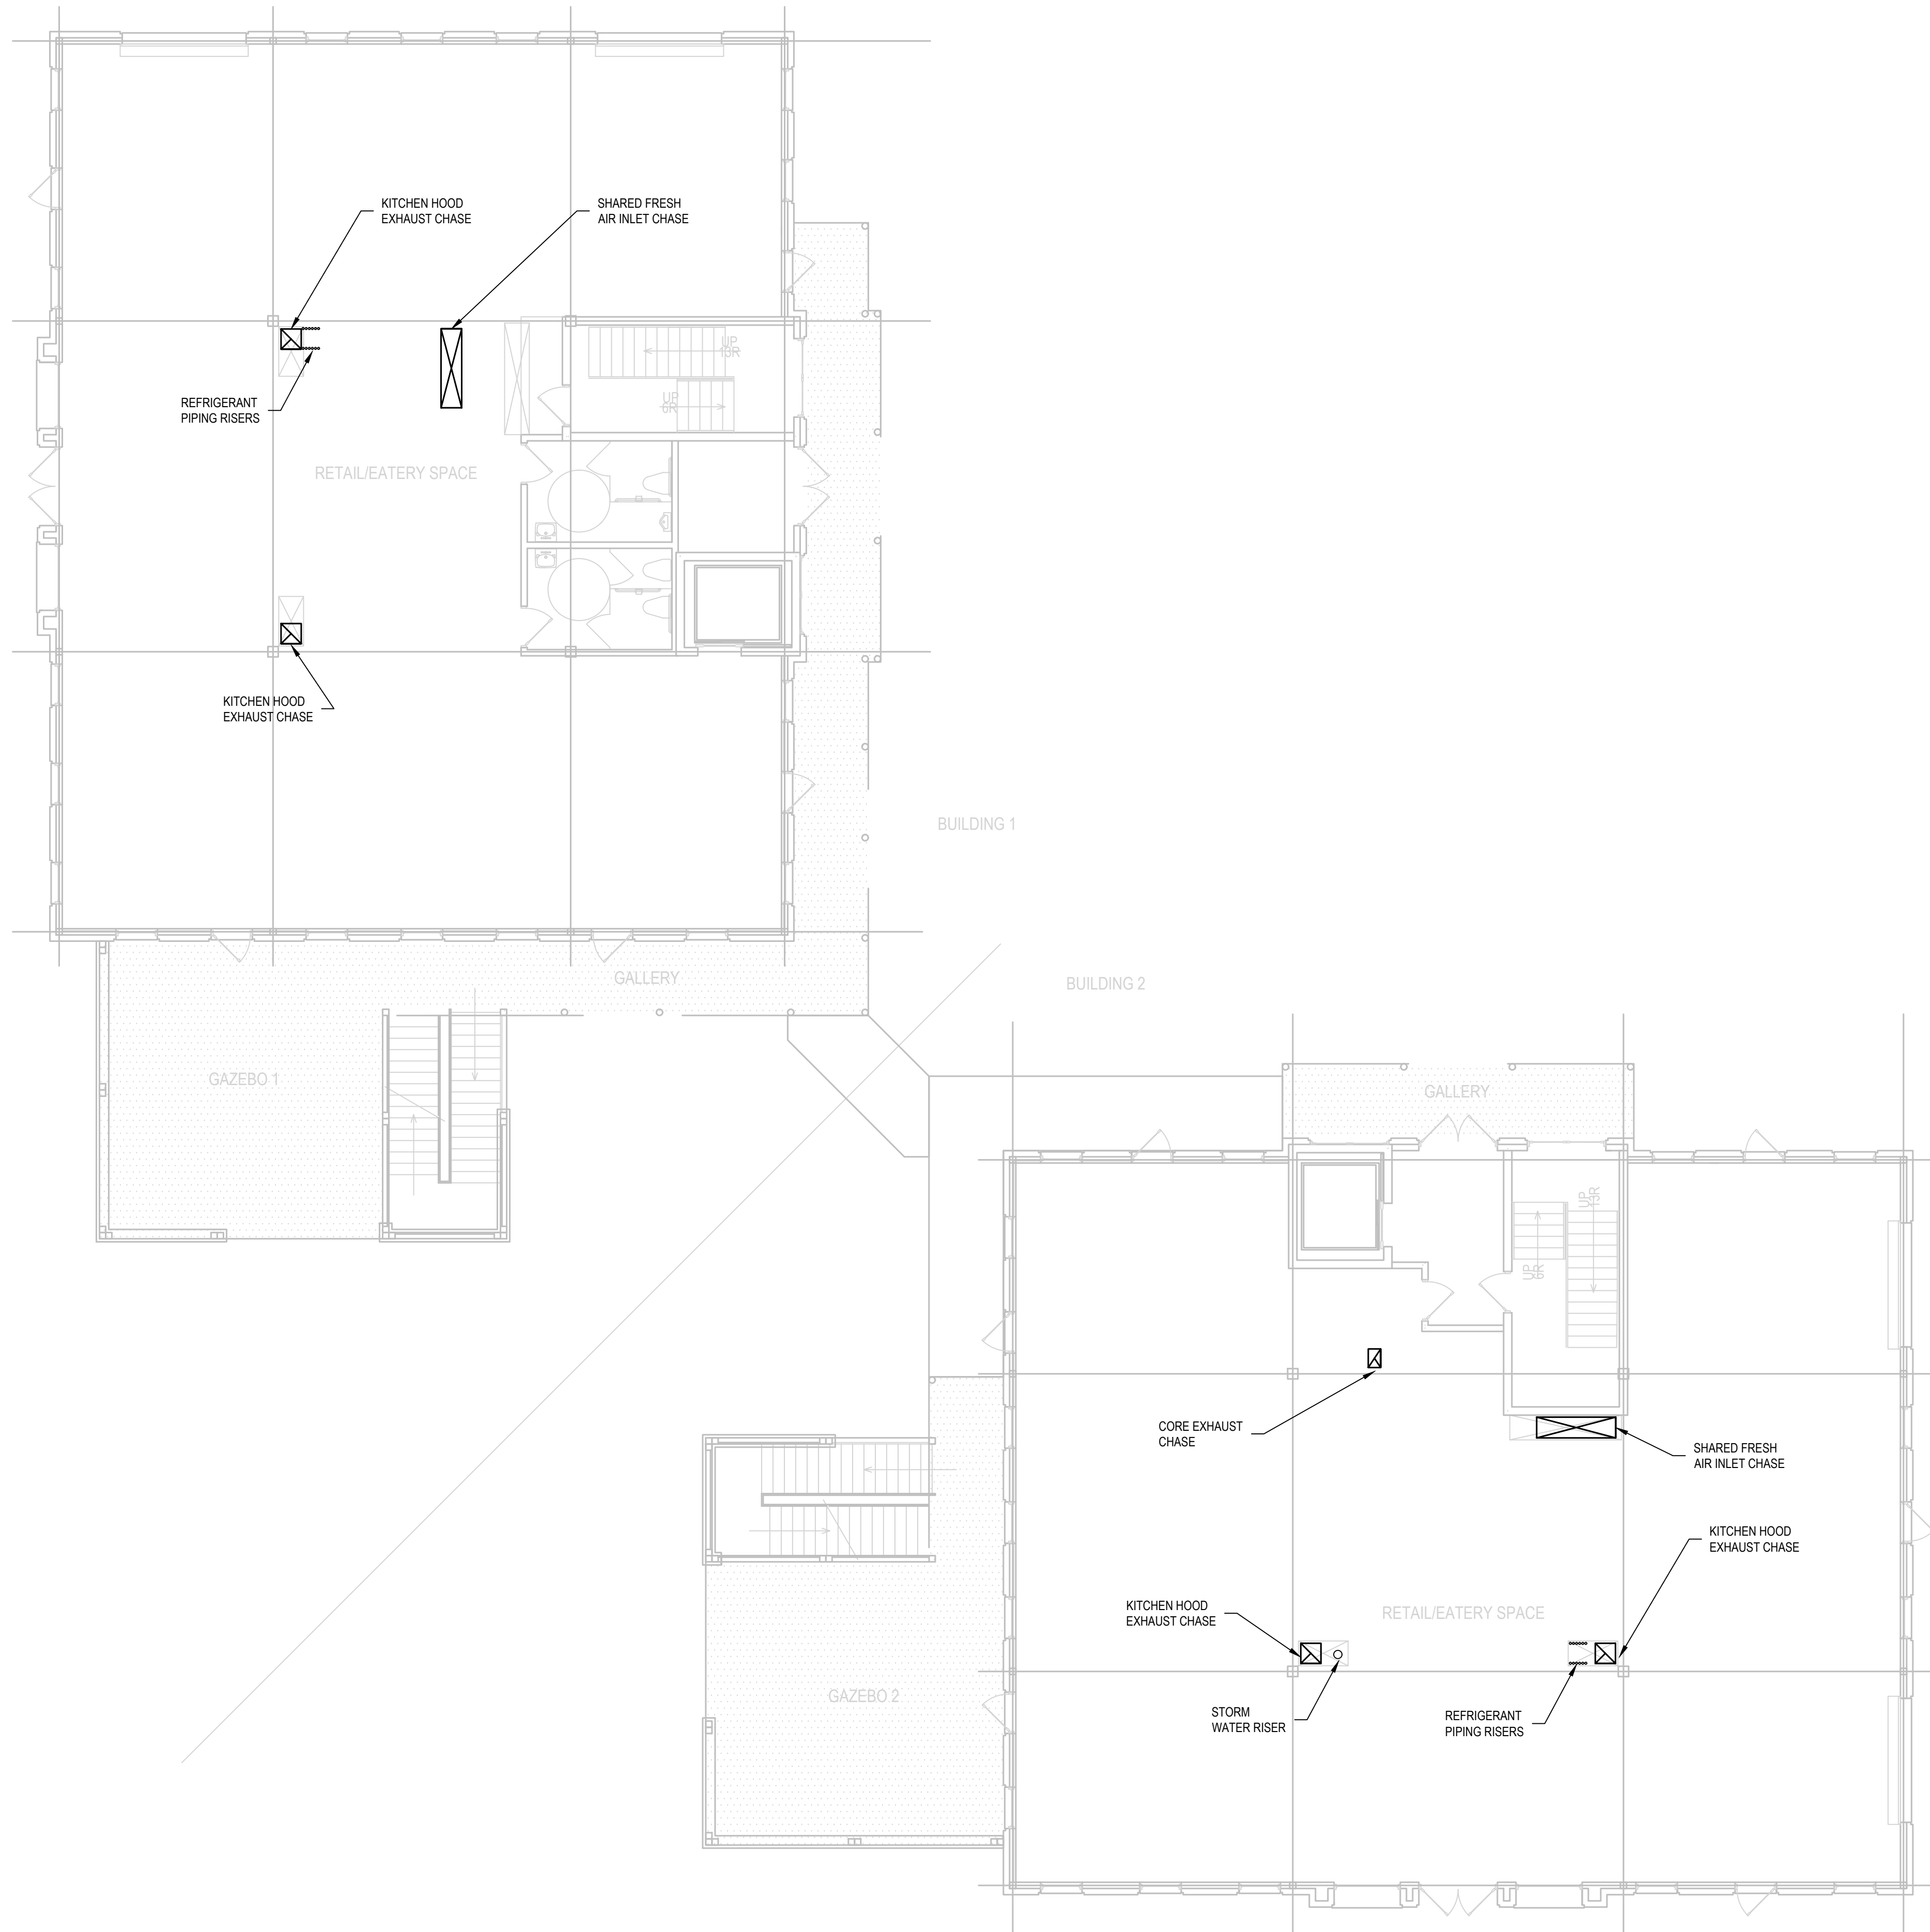

1 MAIN LEVEL FLOOR PLAN - BUILDINGS 1&2
SCALE: 1/8"=1'-0"



Market District

Commercial T5
Buildings 1, 2, 5

Charlotte Drive
Milton, GA

08/25/2019

BRIAN J. FAGAN - PROFESSIONAL ENGINEER
GA LICENSE NUM: 32550 - EXP: 12/31/2018



Design Professional

Issue Date 08/19/2019

▶	Date	Description
0	08/26/2019	PRELIMINARY REVIEW

Project Name Strawberry Fields

Project Number 17027-02

Drawn by CH / BJF

Designed by BJF

Checked by BJF

Mechanical Floor Plans

Description

Sheet Number

M1.1



Market District

Commercial T5
Buildings 1, 2, 5

Charlotte Drive
Milton, GA

08/25/2019

BRIAN J. FAGAN - PROFESSIONAL ENGINEER
GA LICENSE NUM: 32550 - EXP: 12/31/2018



Design Professional

Issue Date 08/19/2019

▶	Date	Description
0	08/26/2019	PRELIMINARY REVIEW

Project Name Strawberry Fields

Project Number 17027-02

Drawn by CH / B/JF

Designed by B/JF


Checked by B/JF

Mechanical Floor Plans

Description

Sheet Number

M1.2

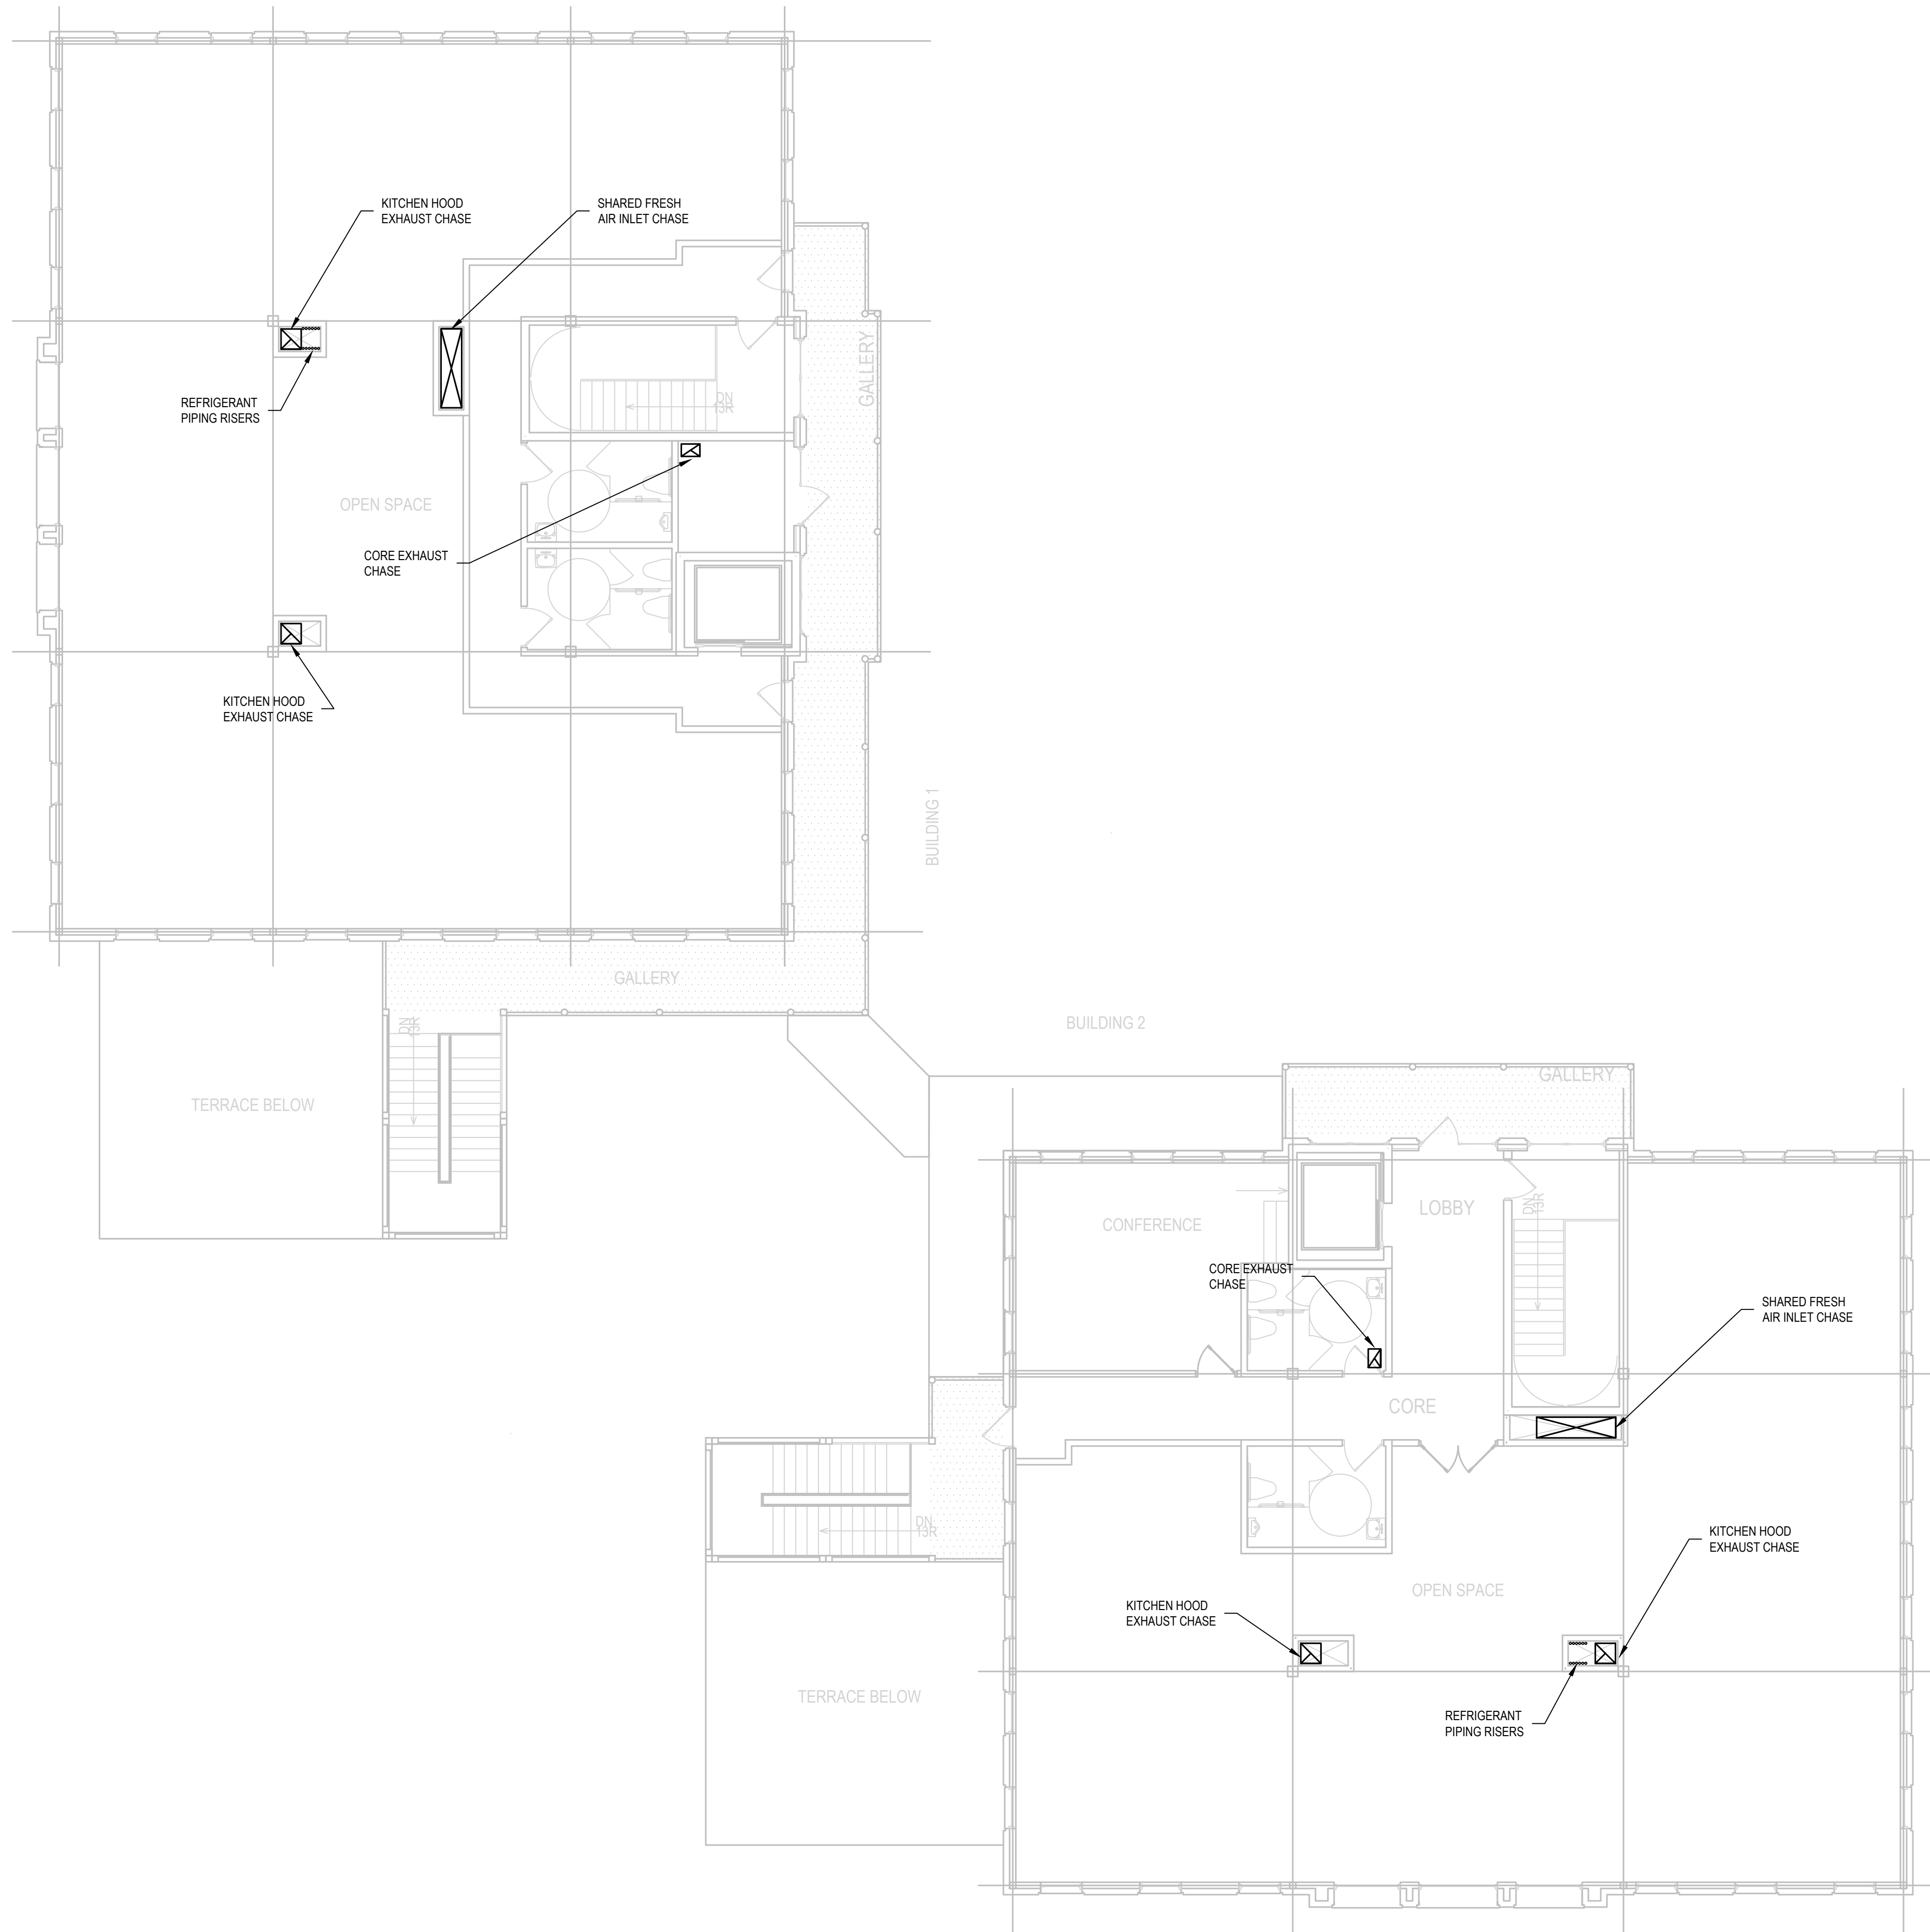

Market District

Commercial T5
Buildings 1, 2, 5

Charlotte Drive
Milton, GA

08/25/2019

BRIAN J. FAGAN - PROFESSIONAL ENGINEER
GA LICENSE NUM: 32550 - EXP: 12/31/2018



Design Professional

Issue Date 08/19/2019

▶	Date	Description
0	08/26/2019	PRELIMINARY REVIEW

Project Name Strawberry Fields

Project Number 17027-02

Drawn by CH / B/JF

Designed by B/JF



Checked by B/JF

Mechanical Floor Plans

Description

Sheet Number

M1.3

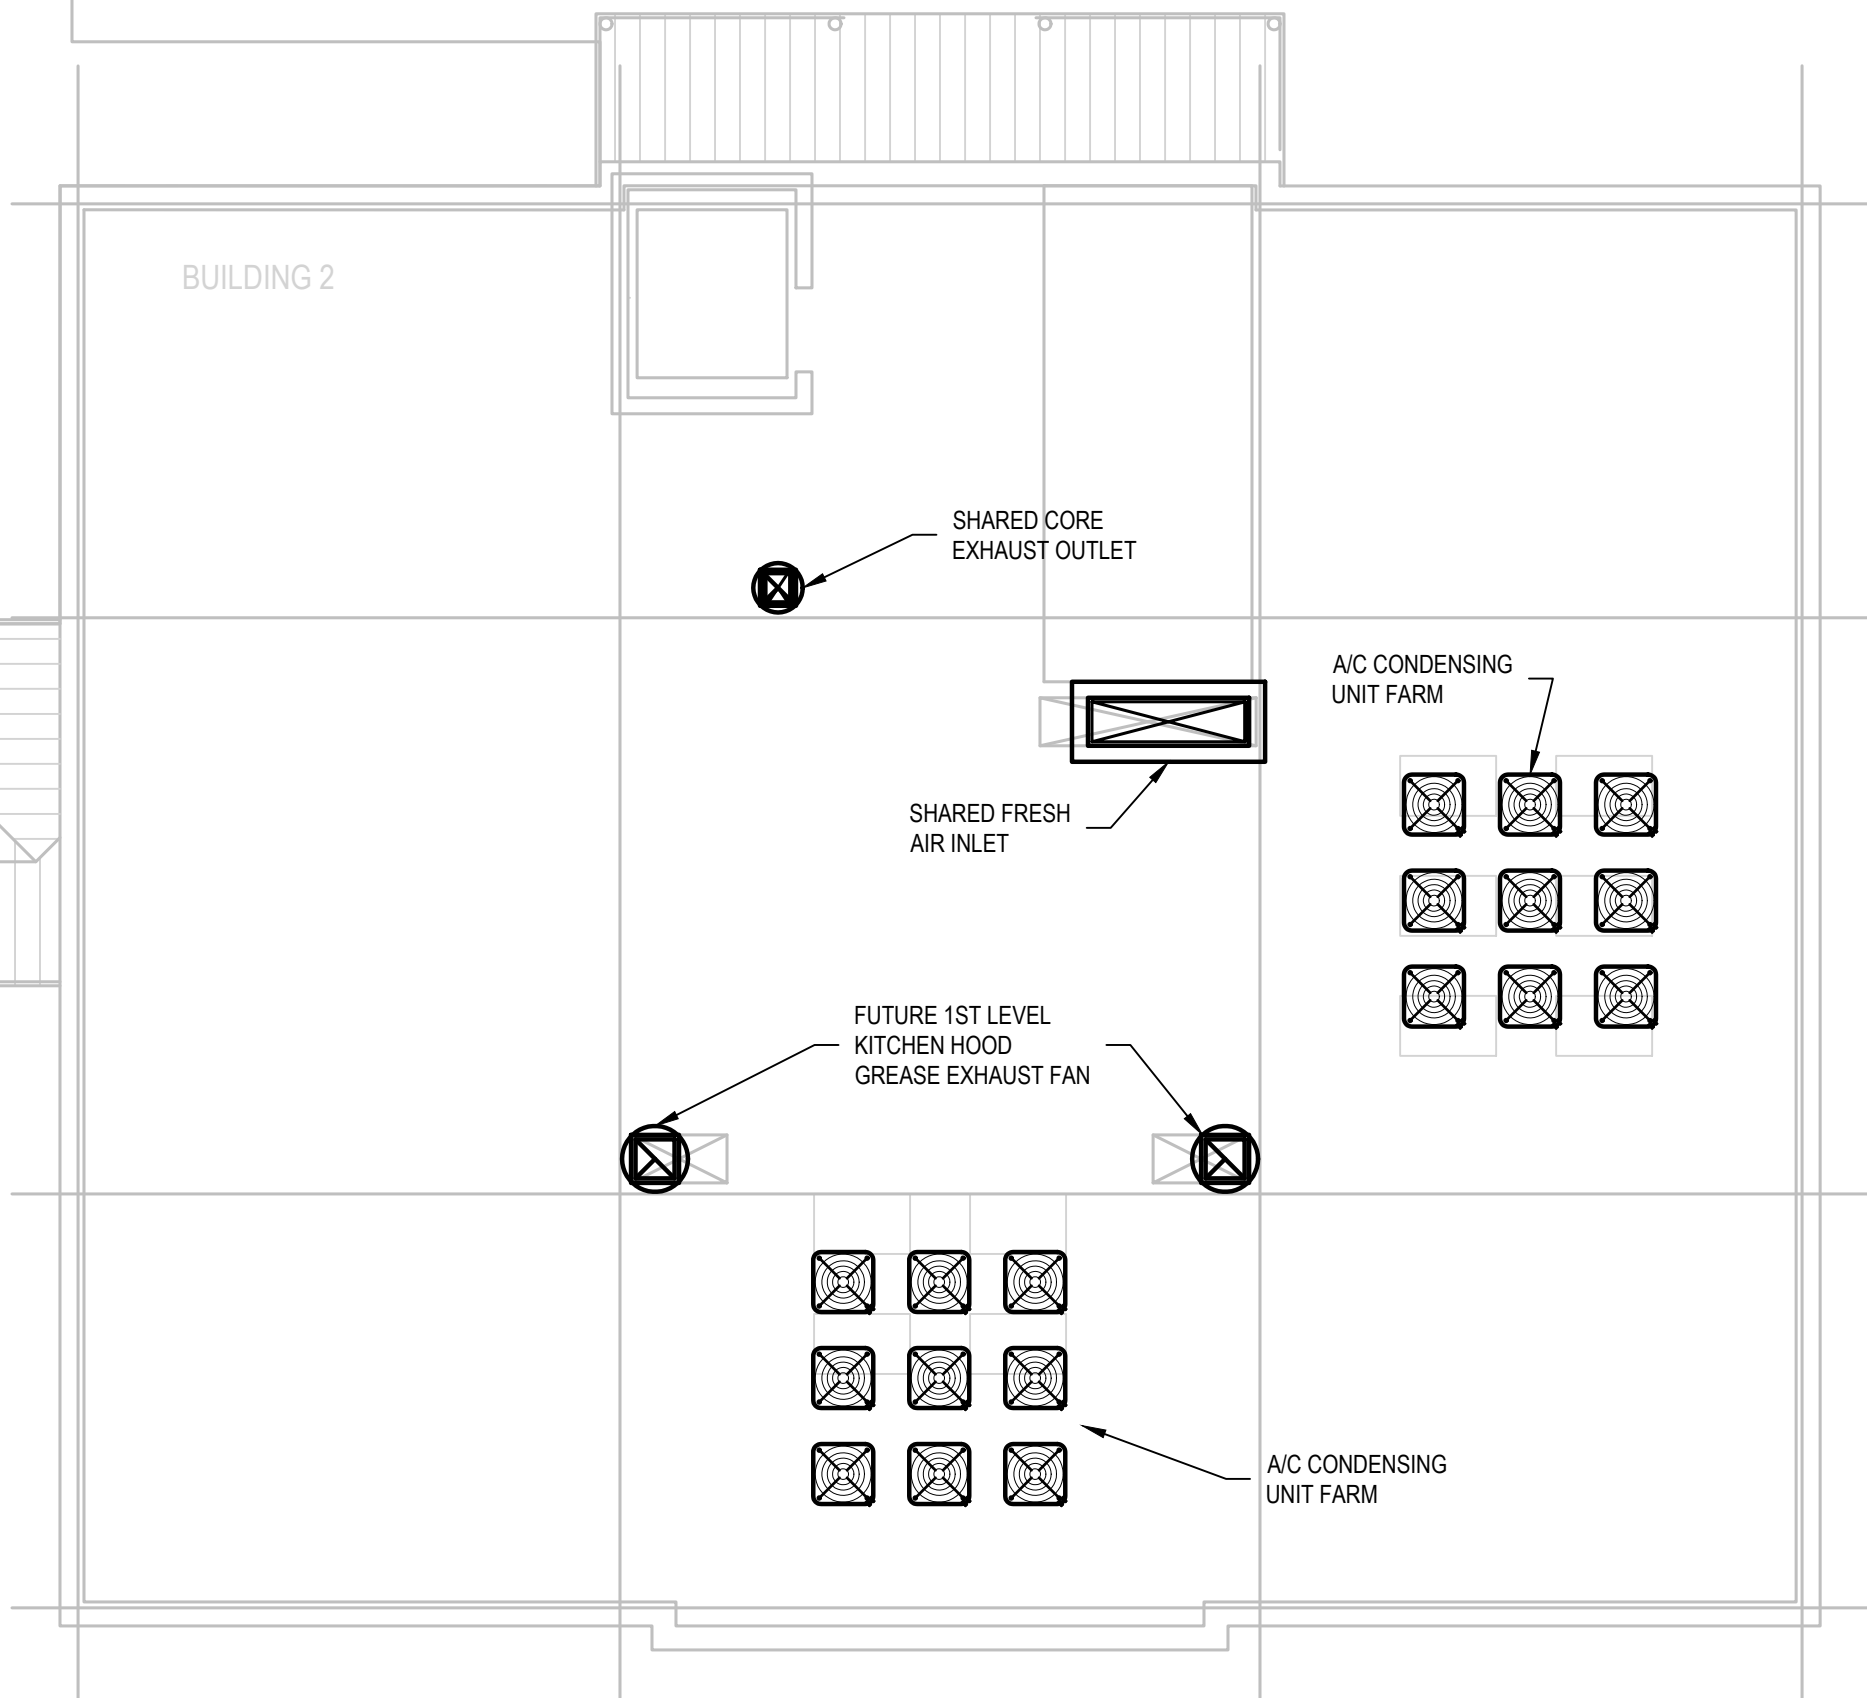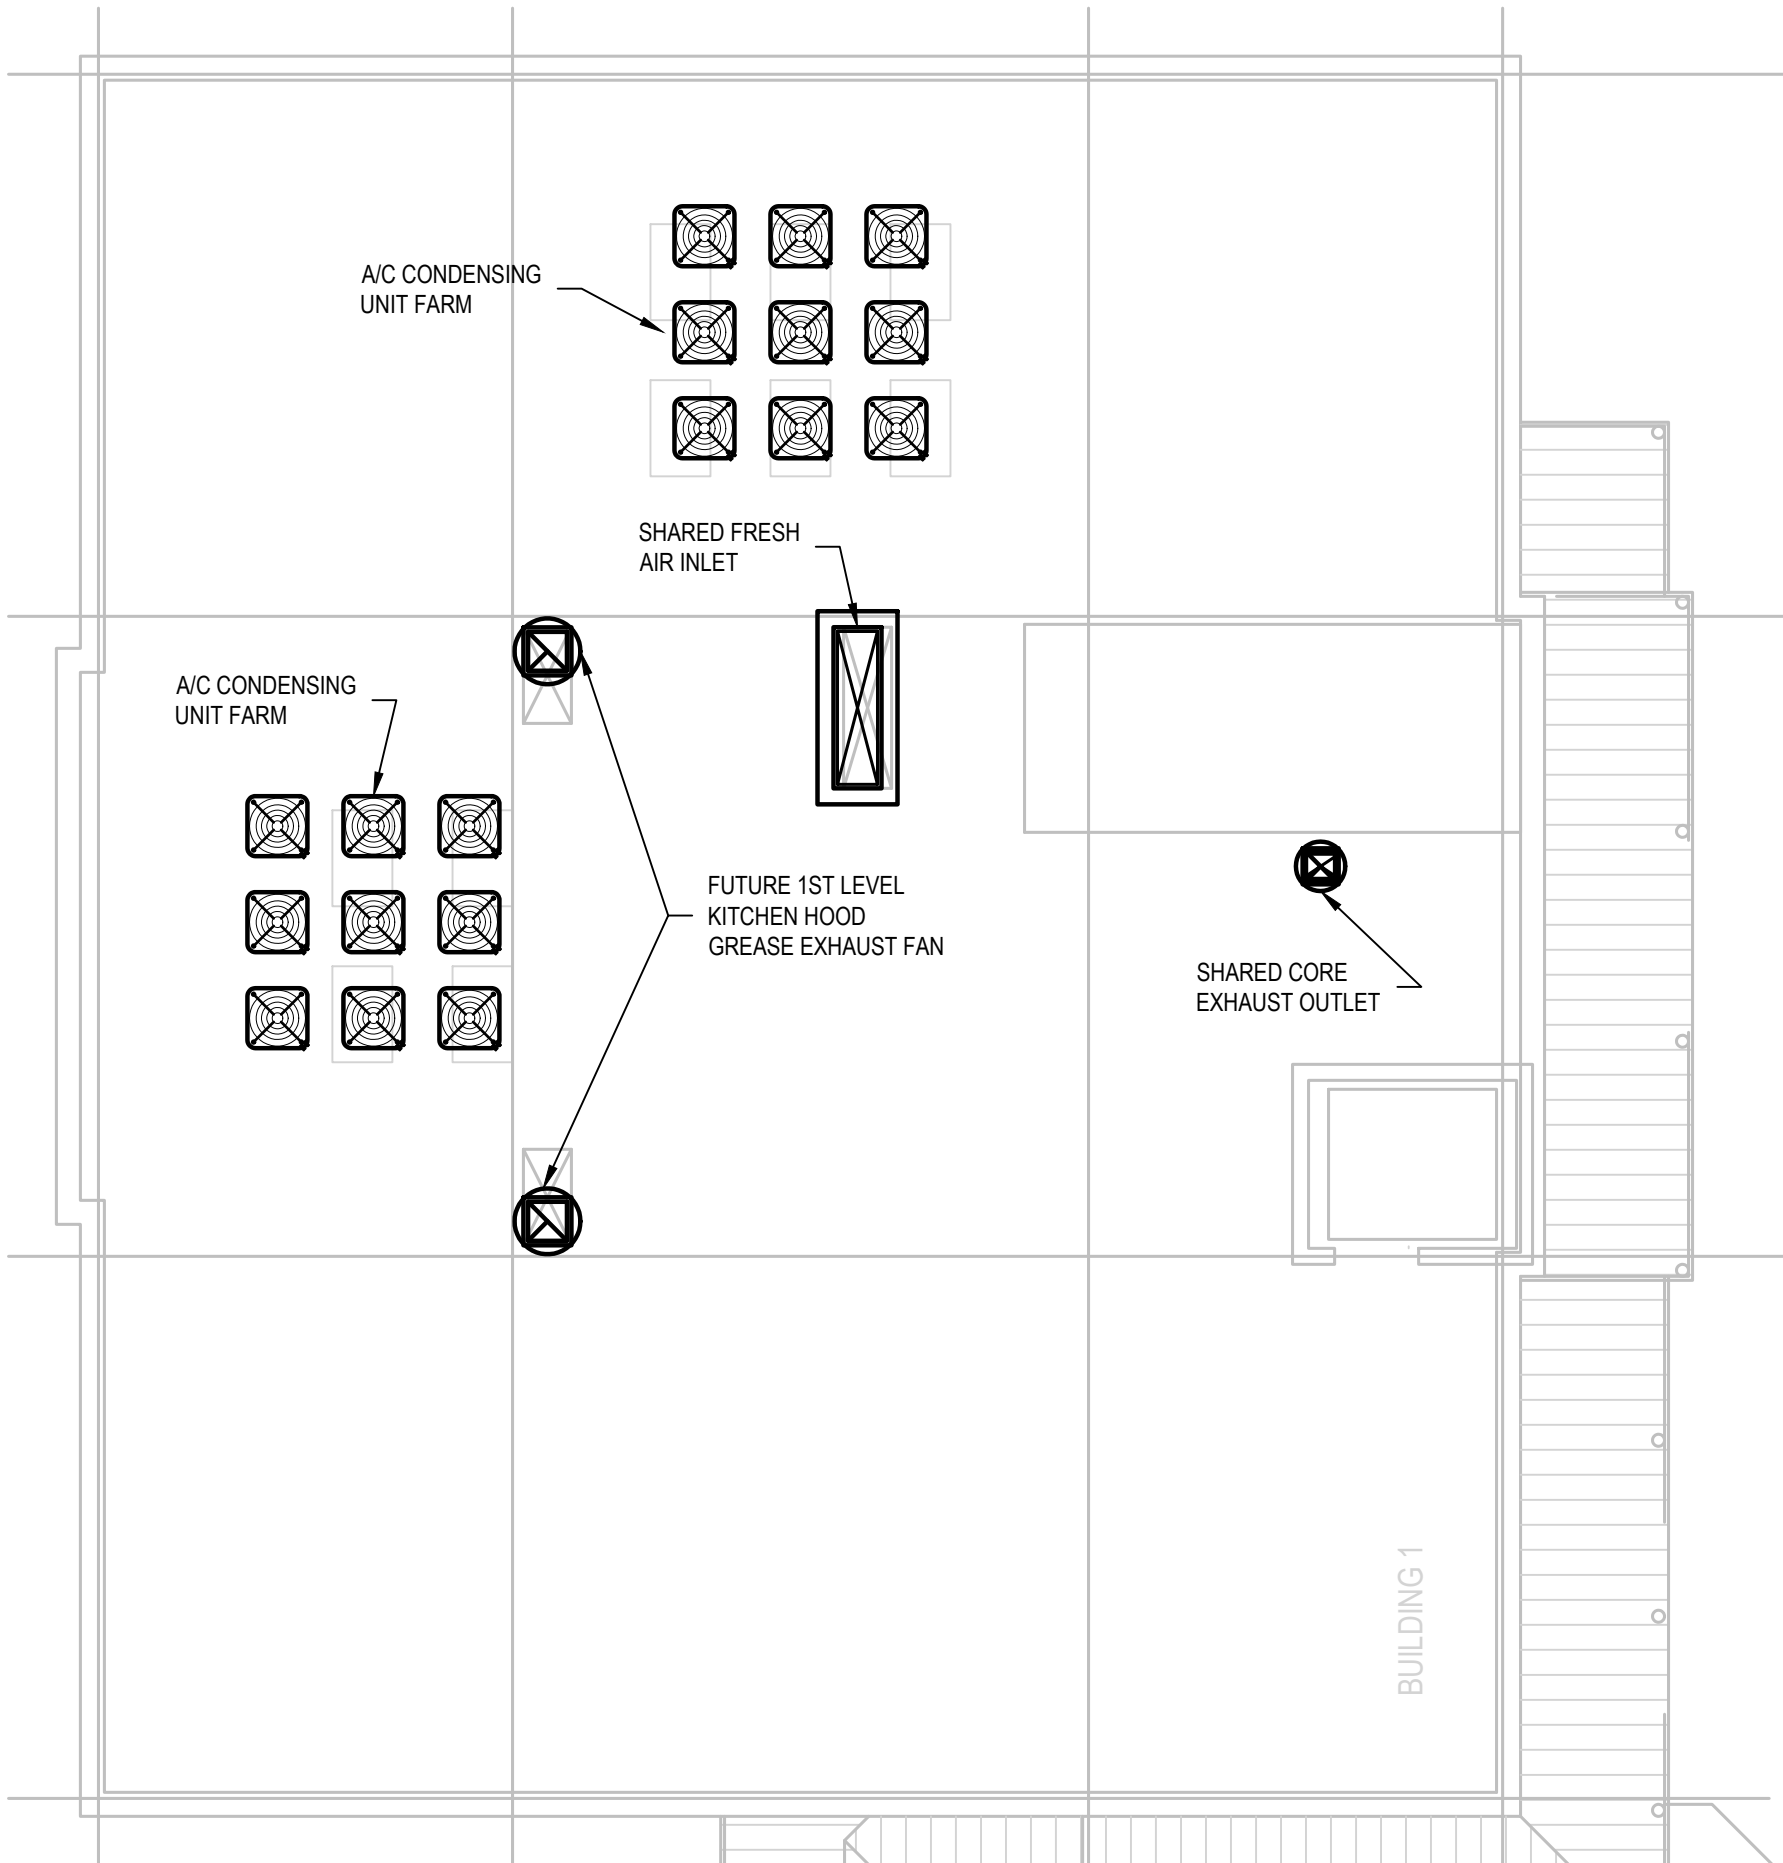

1

ROOF TERRACE LEVEL FLOOR PLAN - BUILDINGS 1&2

SCALE: 1/8"=1'-0"



Market District

Commercial T5
Buildings 1, 2, 5

Charlotte Drive
Milton, GA

08/25/2019

BRIAN J. FAGAN - PROFESSIONAL ENGINEER
GA LICENSE NUM: 32550 - EXP: 12/31/2018



Design Professional

Issue Date 08/19/2019

▶	Date	Description
0	08/26/2019	PRELIMINARY REVIEW

Project Name Strawberry Fields

Project Number 17027-02

Drawn by CH / BJF

Designed by BJF


Checked by BJF

Mechanical Floor Plans

Description

Sheet Number

M1.4

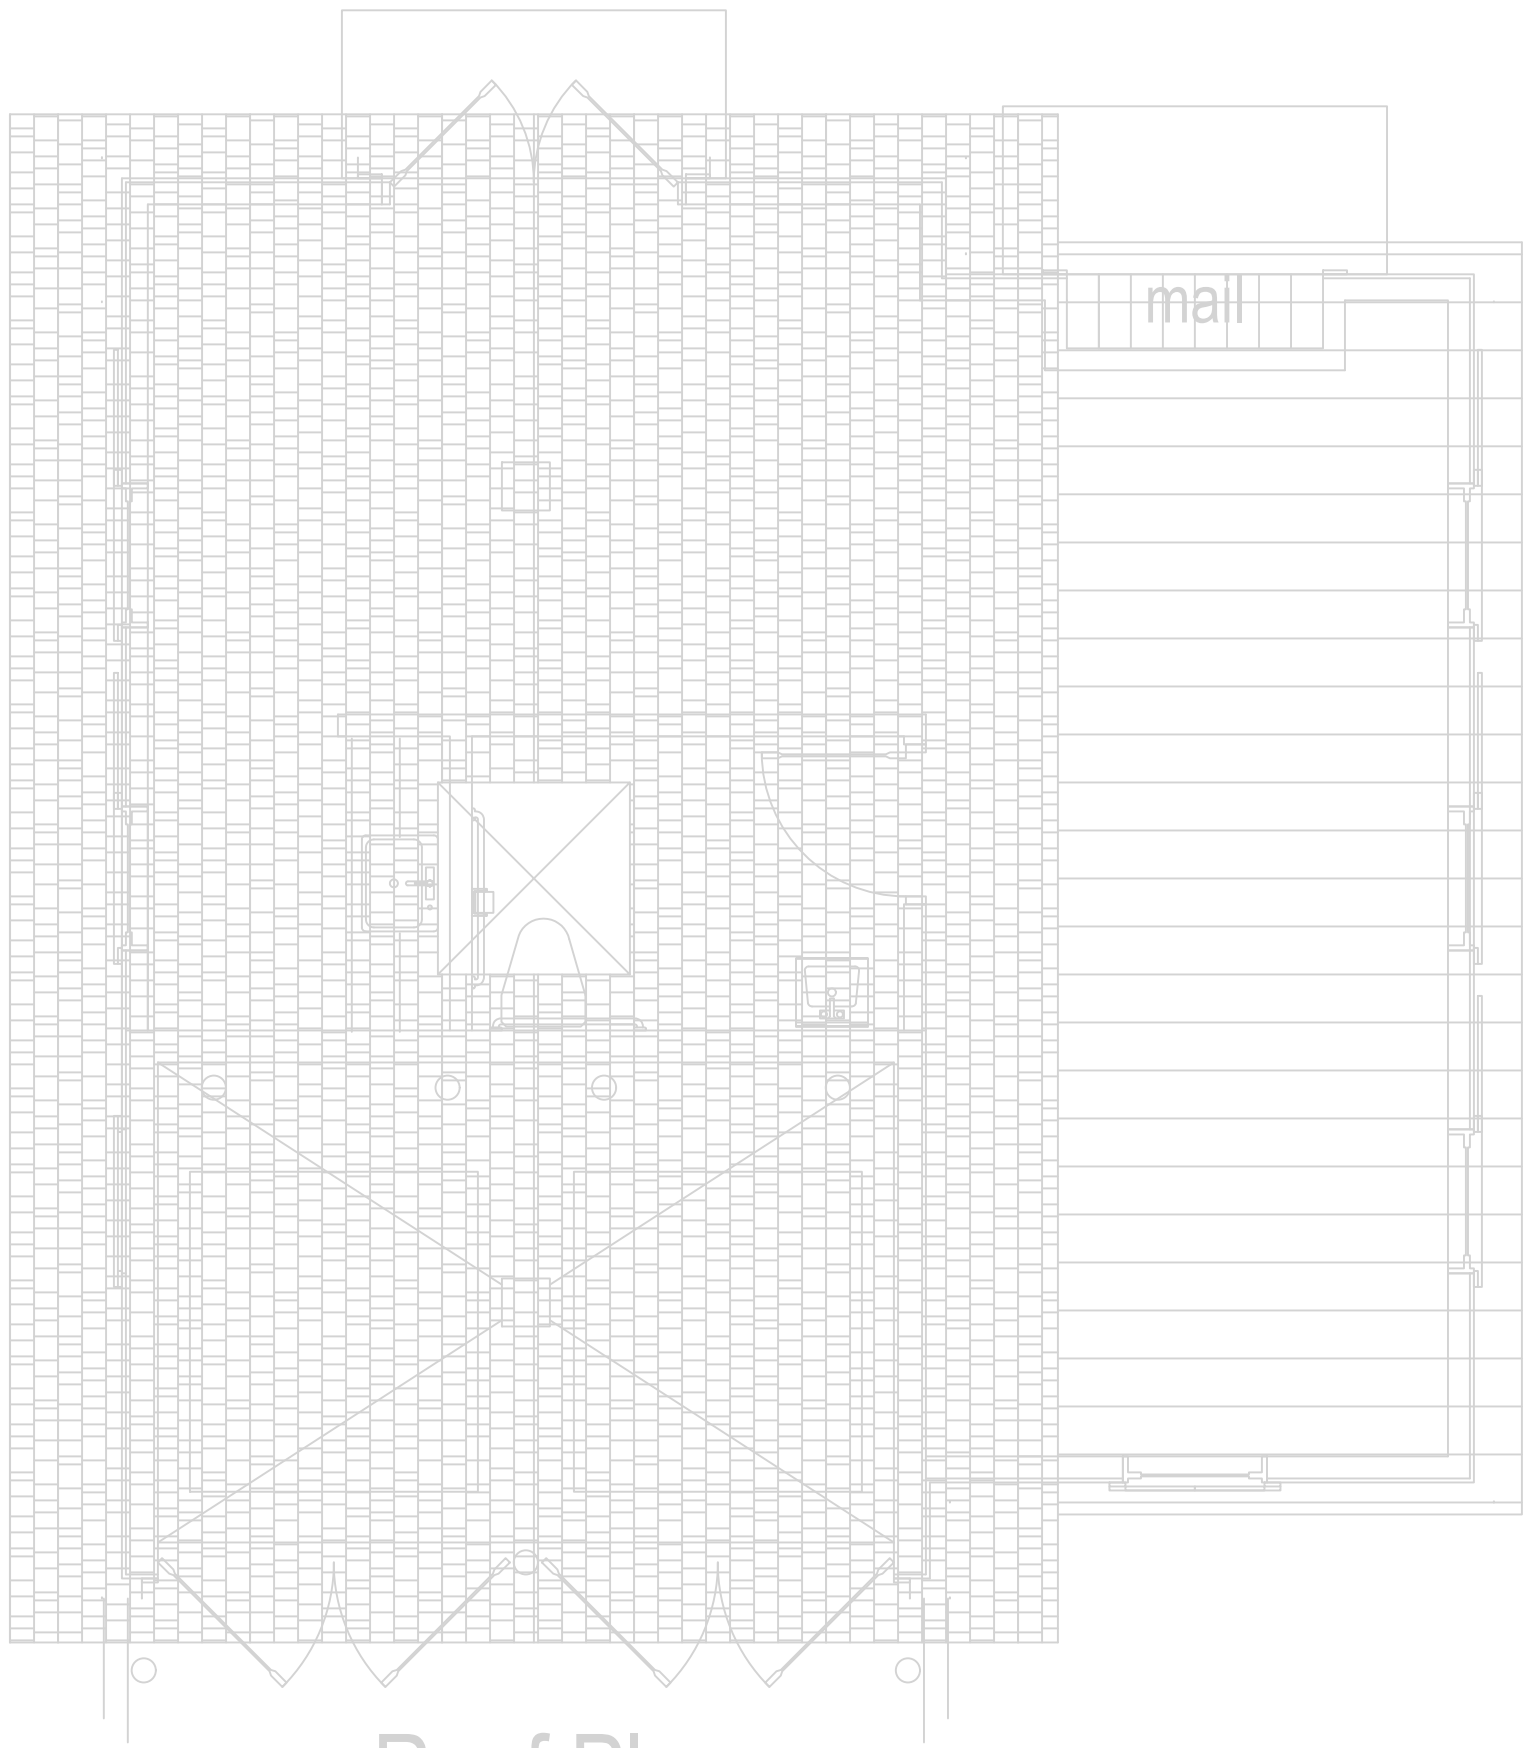


Roof Plan

2

ROOF PLAN - BUILDING 5

SCALE: 1/4"=1'-0"

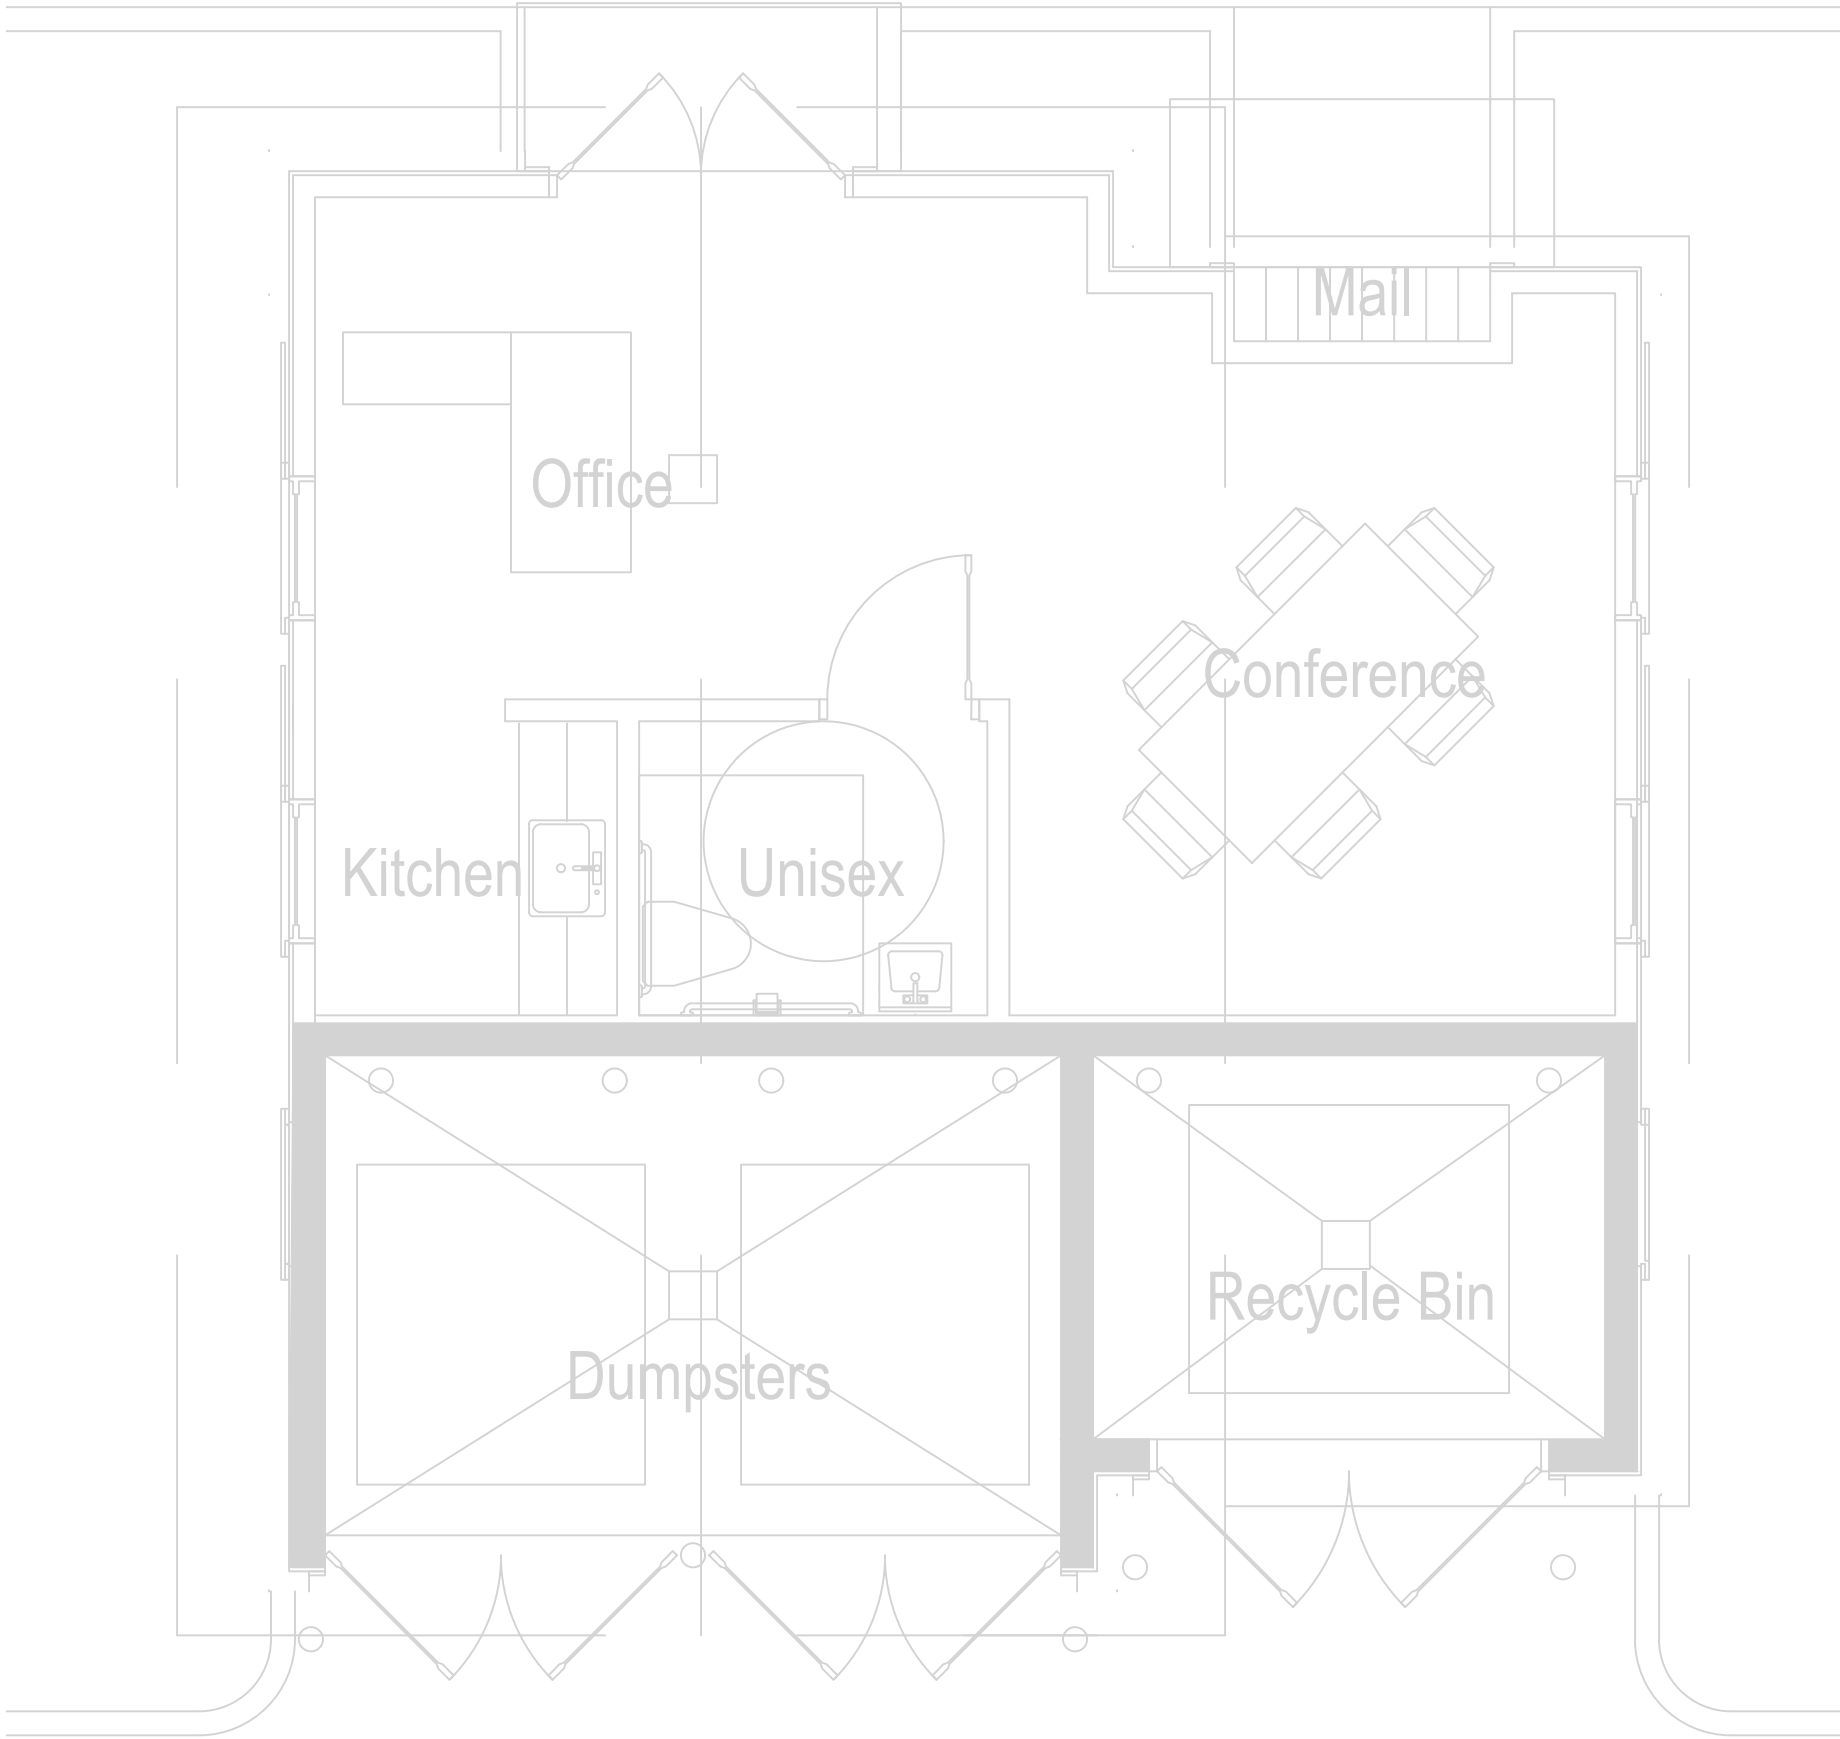

Floor Plan

1

MAIN LEVEL FLOOR PLAN - BUILDING 5

SCALE: 1/4"=1'-0"



Market District

Commercial T5
Buildings 1, 2, 5

Charlotte Drive
Milton, GA

08/25/2019

BRIAN J. FAGAN - PROFESSIONAL ENGINEER
GA LICENSE NUM: 32550 - EXP: 12/31/2018



Design Professional

Issue Date 08/19/2019

▶	Date	Description
0	08/26/2019	PRELIMINARY REVIEW

Project Name Strawberry Fields

Project Number 17027-02

Drawn by CH / BJF

Designed by BJF


Checked by BJF

Mechanical Floor Plans

Description

Sheet Number

M2.0

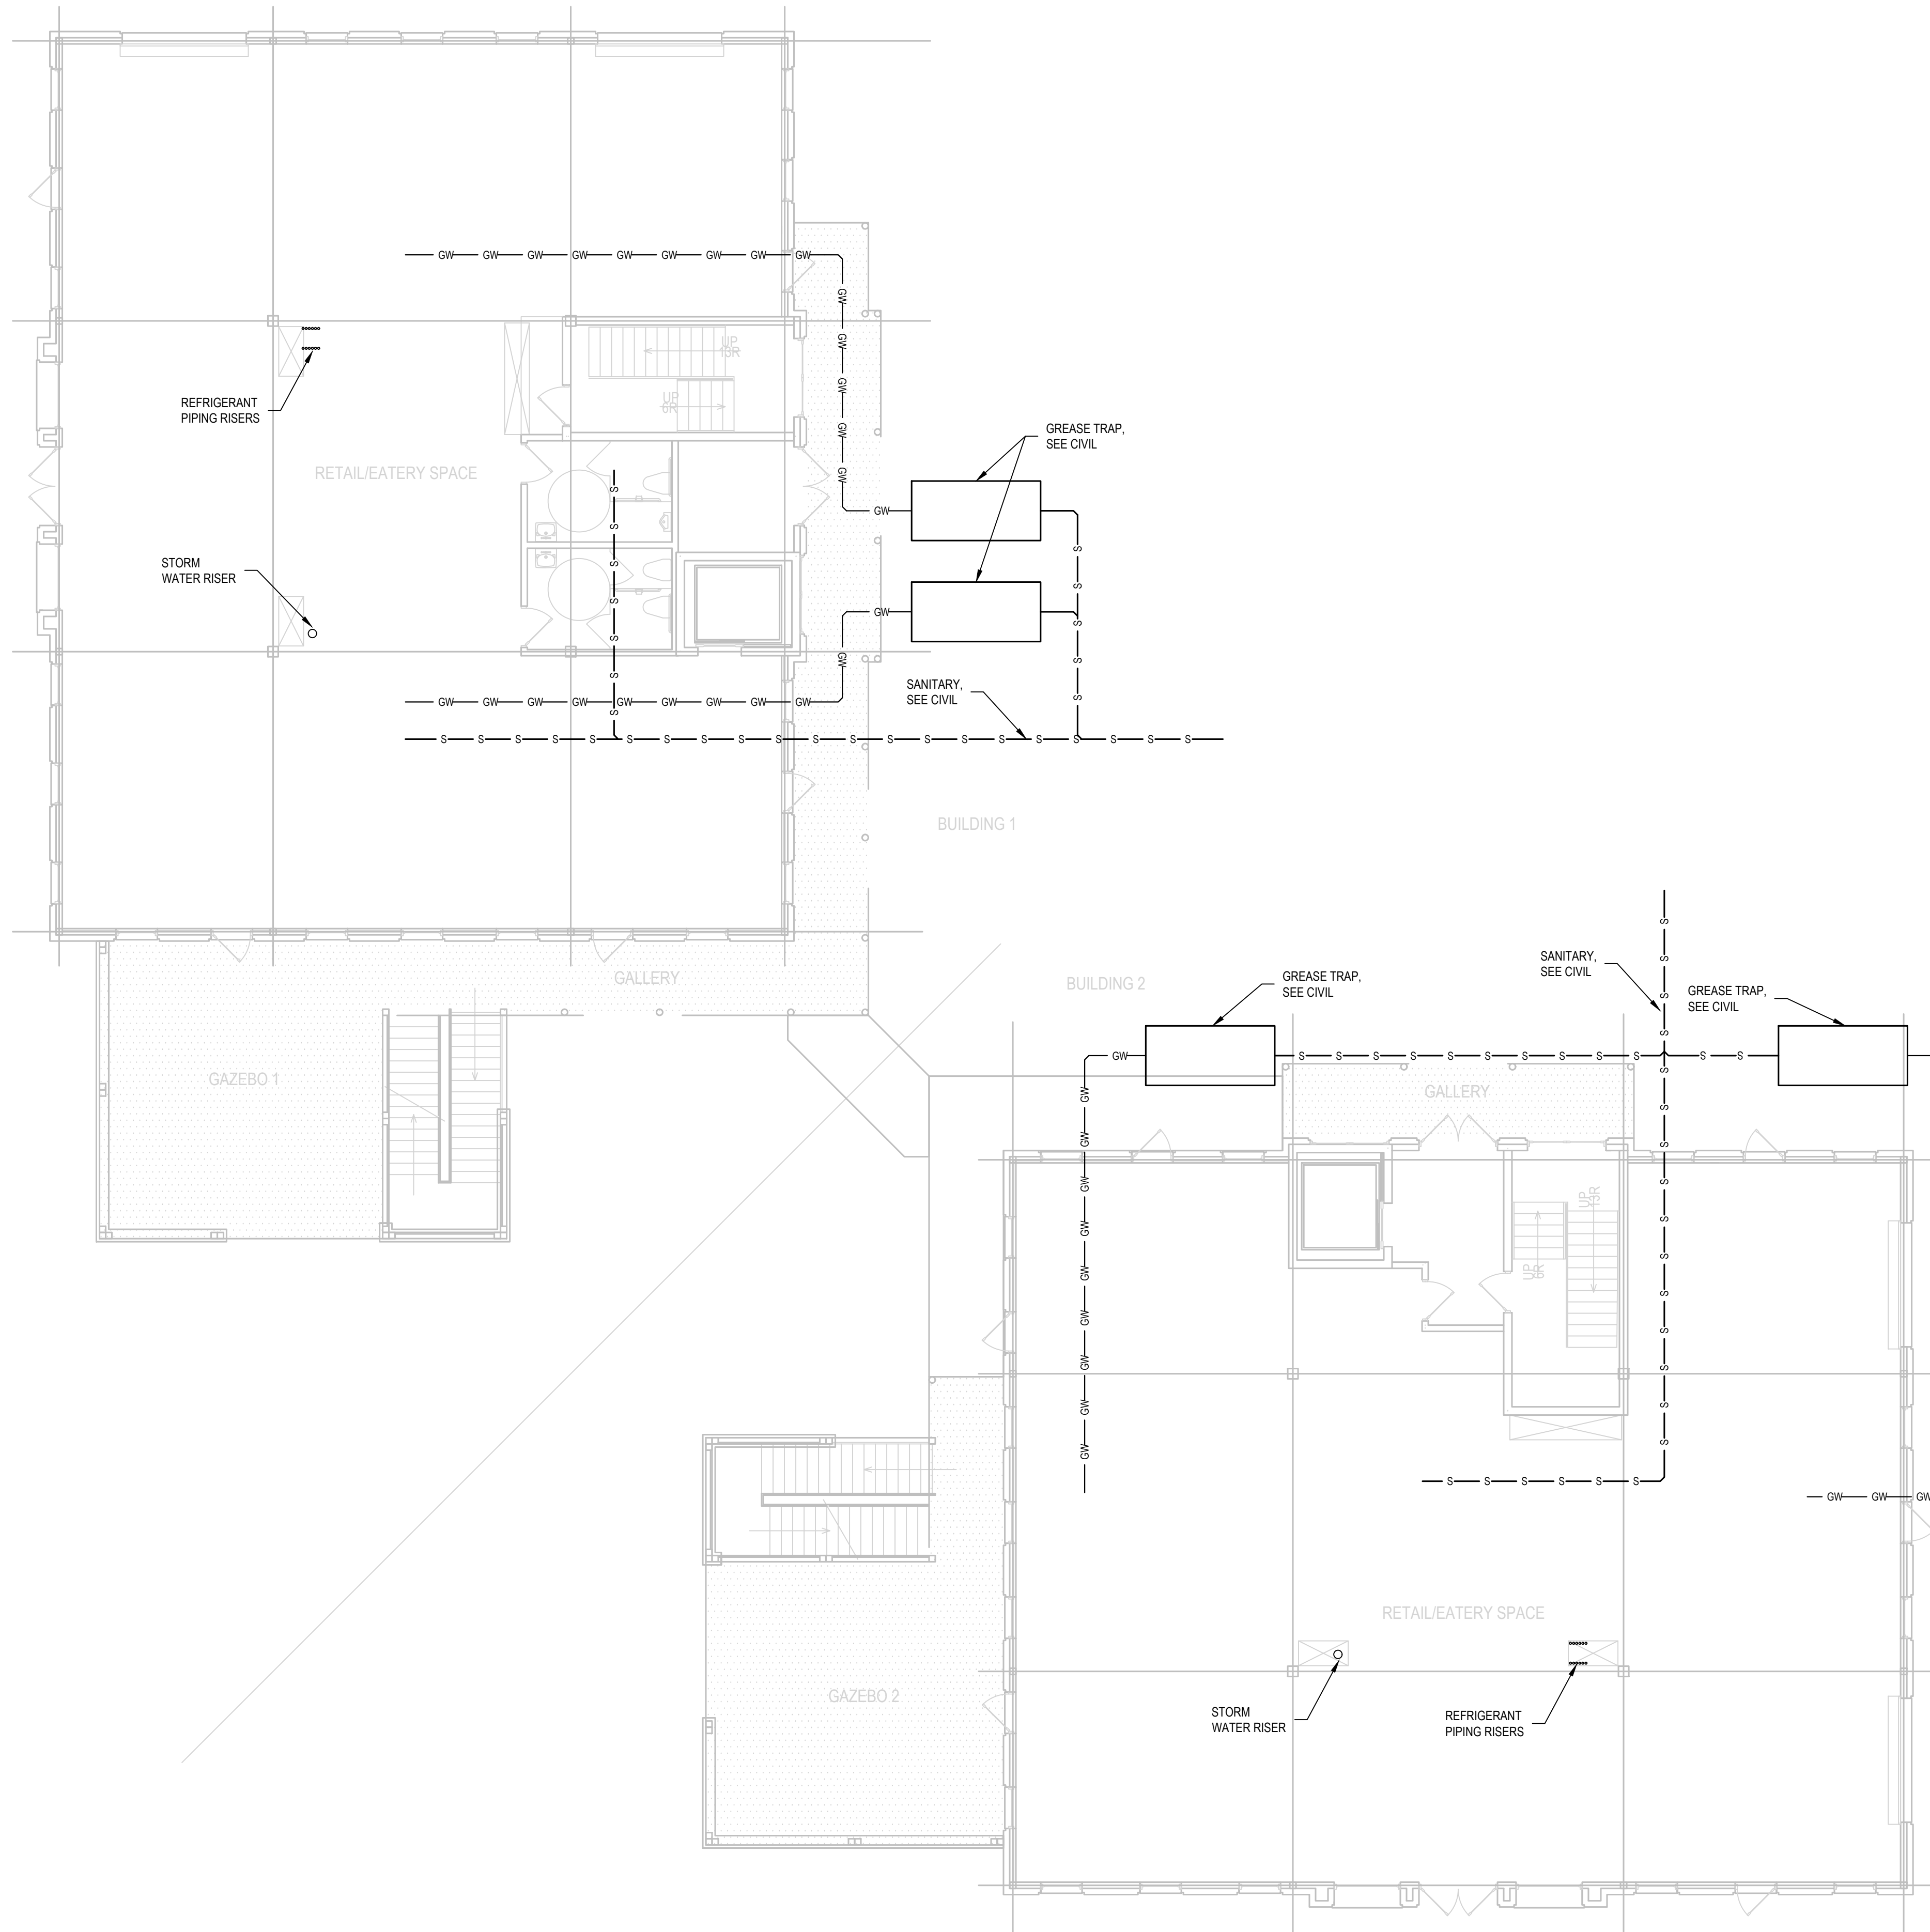

Market District

Commercial T5
Buildings 1, 2, 5

Charlotte Drive
Milton, GA

08/25/2019

BRIAN J. FAGAN - PROFESSIONAL ENGINEER
GA LICENSE NUM: 32550 - EXP: 12/31/2018



Design Professional

Issue Date 08/19/2019

Date	Description
0 08/26/2019	PRELIMINARY REVIEW

Project Name Strawberry Fields

Project Number 17027-02

Drawn by CH / B/F

Designed by B/F

Checked by B/F

Plumbing Floor Plan

Description

Sheet Number

P1.1



Market District

Commercial T5
Buildings 1, 2, 5

Charlotte Drive
Milton, GA

08/25/2019

BRIAN J. FAGAN - PROFESSIONAL ENGINEER
GA LICENSE NUM: 32550 - EXP: 12/31/2018



Design Professional

Issue Date 08/19/2019

Date	Description
0	08/26/2019 PRELIMINARY REVIEW

Project Name Strawberry Fields

Project Number 17027-02

Drawn by CH / B/JF

Designed by B/JF

Checked by B/JF

Plumbing Floor Plan

Description

Sheet Number

P1.2



Market District

Commercial T5
Buildings 1, 2, 5

Charlotte Drive
Milton, GA

08/25/2019

BRIAN J. FAGAN - PROFESSIONAL ENGINEER
GA LICENSE NUM: 32550 - EXP: 12/31/2018



Design Professional

Issue Date 08/19/2019

▶	Date	Description
0	08/26/2019	PRELIMINARY REVIEW

Project Name Strawberry Fields

Project Number 17027-02

Drawn by CH / B/JF

Designed by B/JF


Checked by B/JF

Plumbing Floor Plan

Description

Sheet Number

P1.3

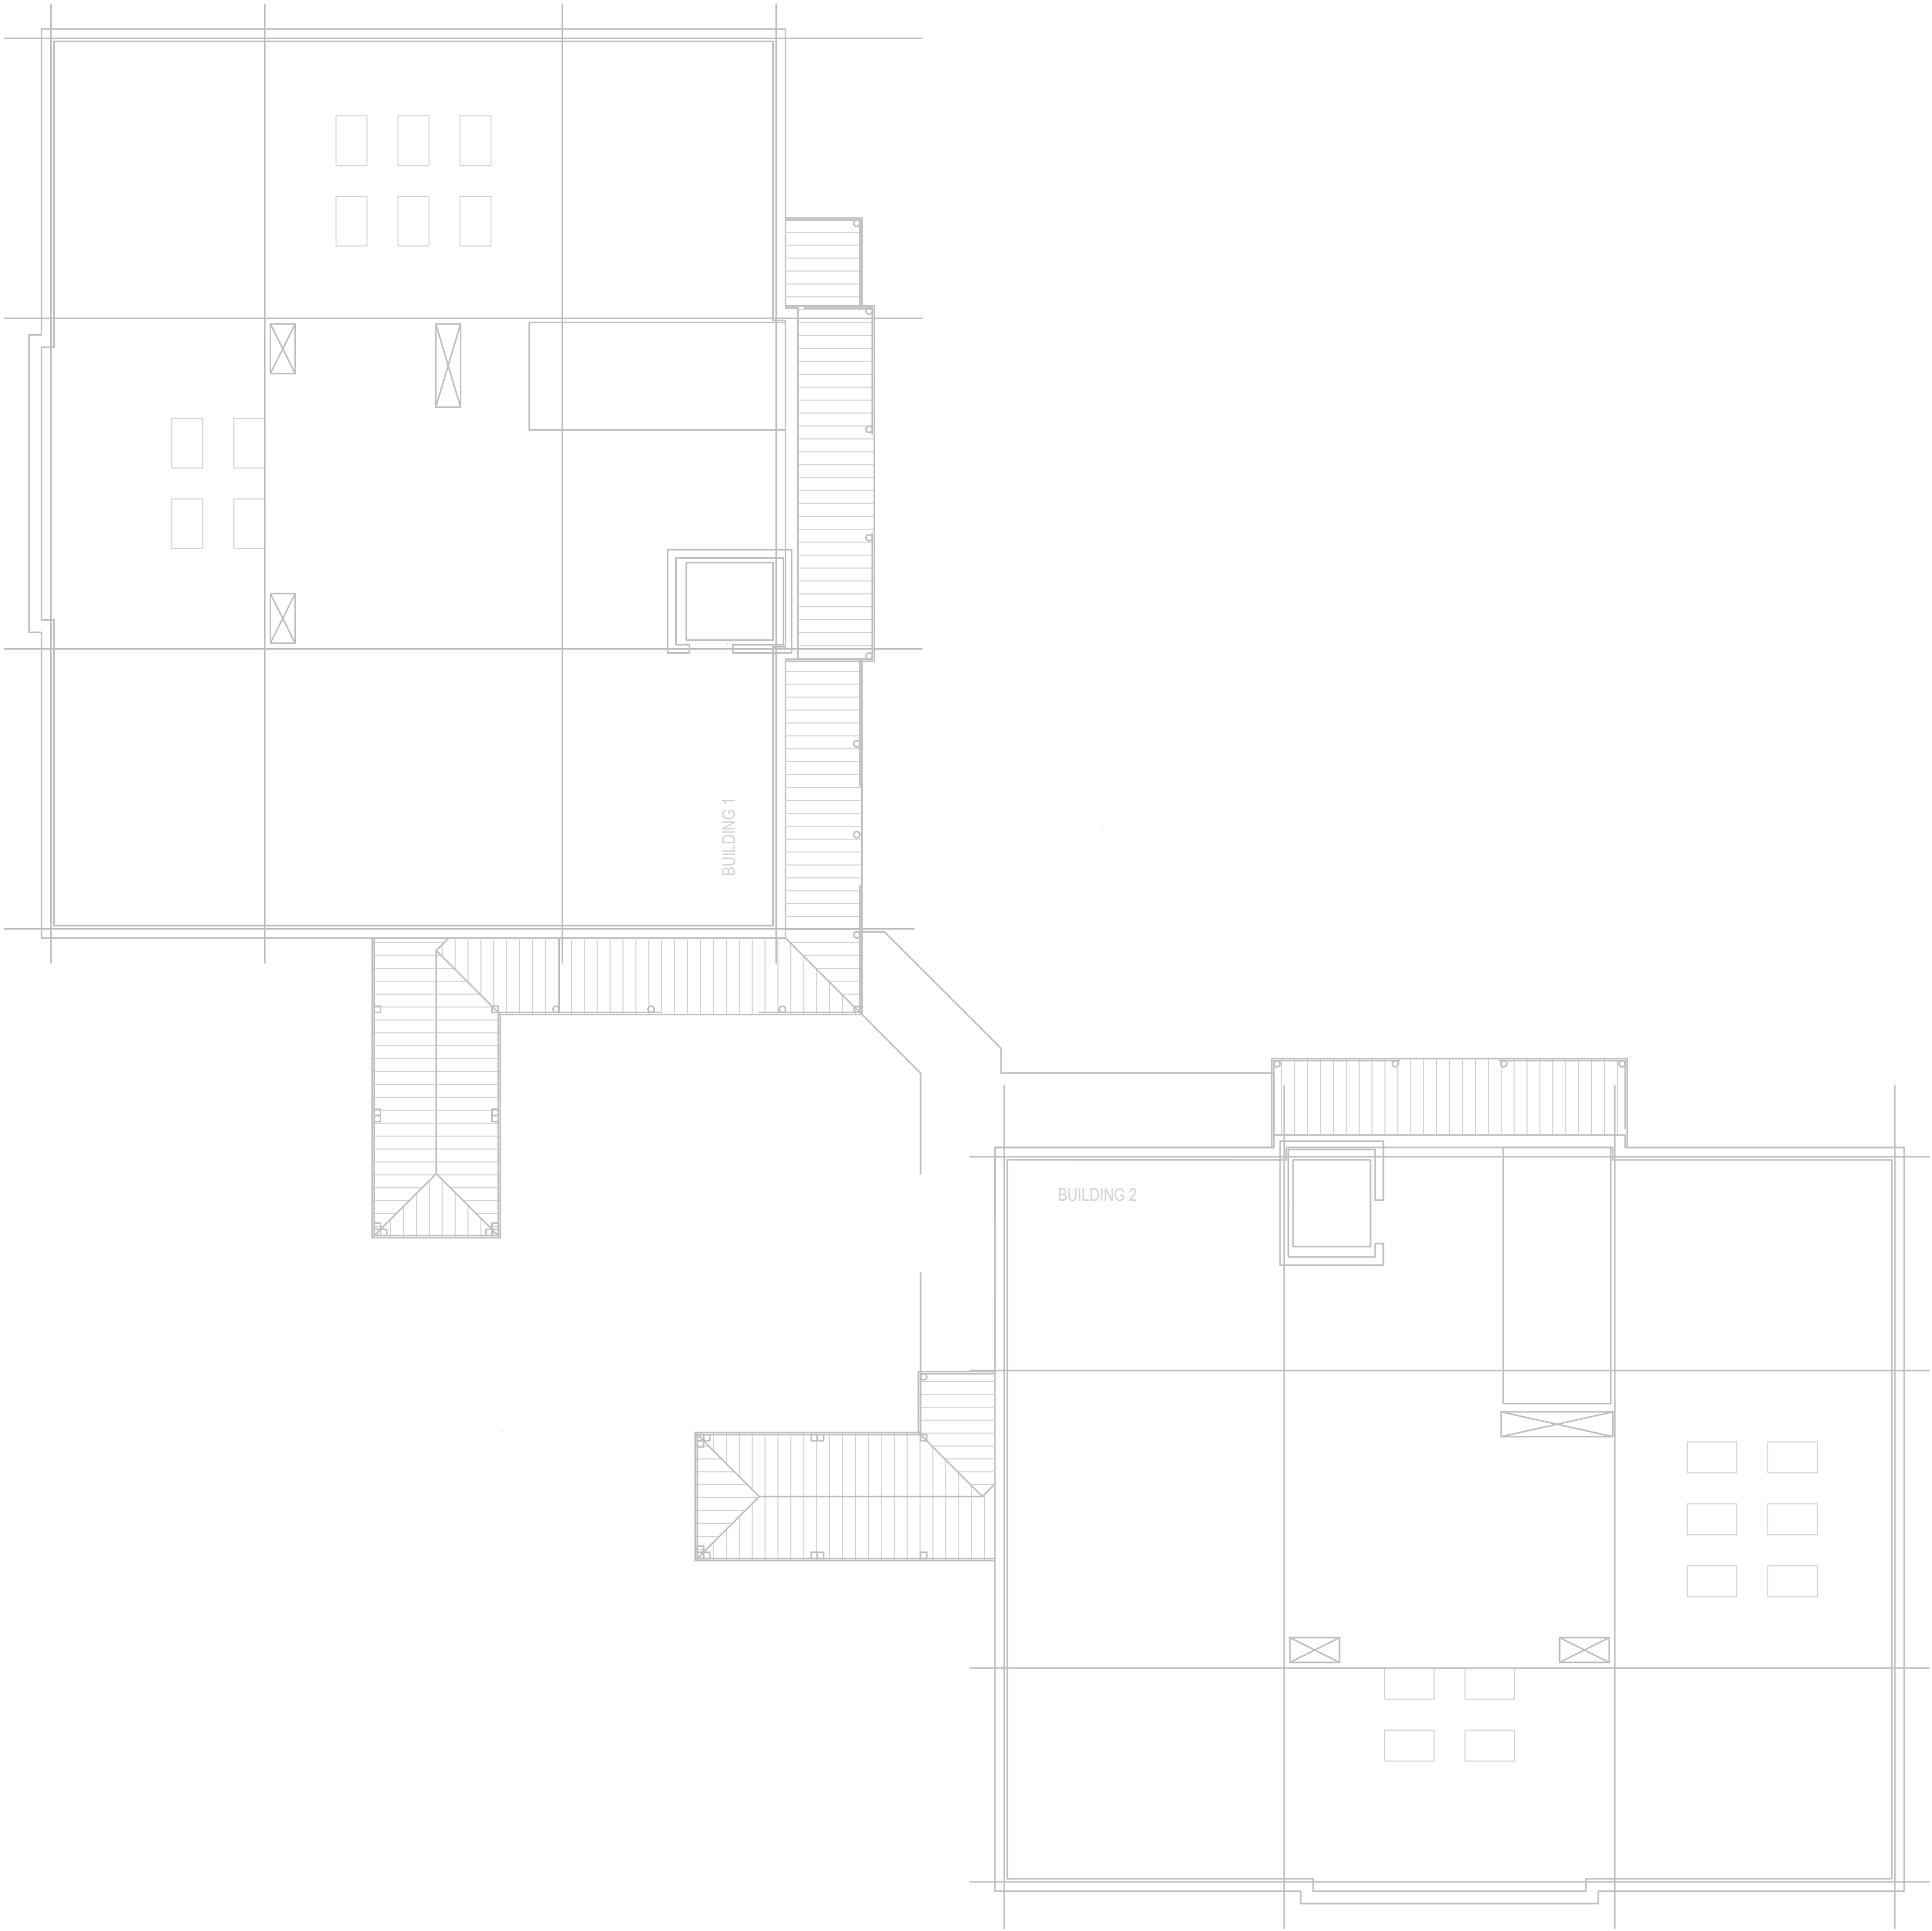

Market District

Commercial T5
Buildings 1, 2, 5

Charlotte Drive
Milton, GA

08/25/2019

BRIAN J. FAGAN - PROFESSIONAL ENGINEER
GA LICENSE NUM: 32550 - EXP: 12/31/2018



Design Professional

Issue Date 08/19/2019

▶	Date	Description
0	08/26/2019	PRELIMINARY REVIEW

Project Name Strawberry Fields

Project Number 17027-02

Drawn by CH / BJF

Designed by BJF


Checked by BJF

Plumbing Floor Plan

Description

Sheet Number

P1.4

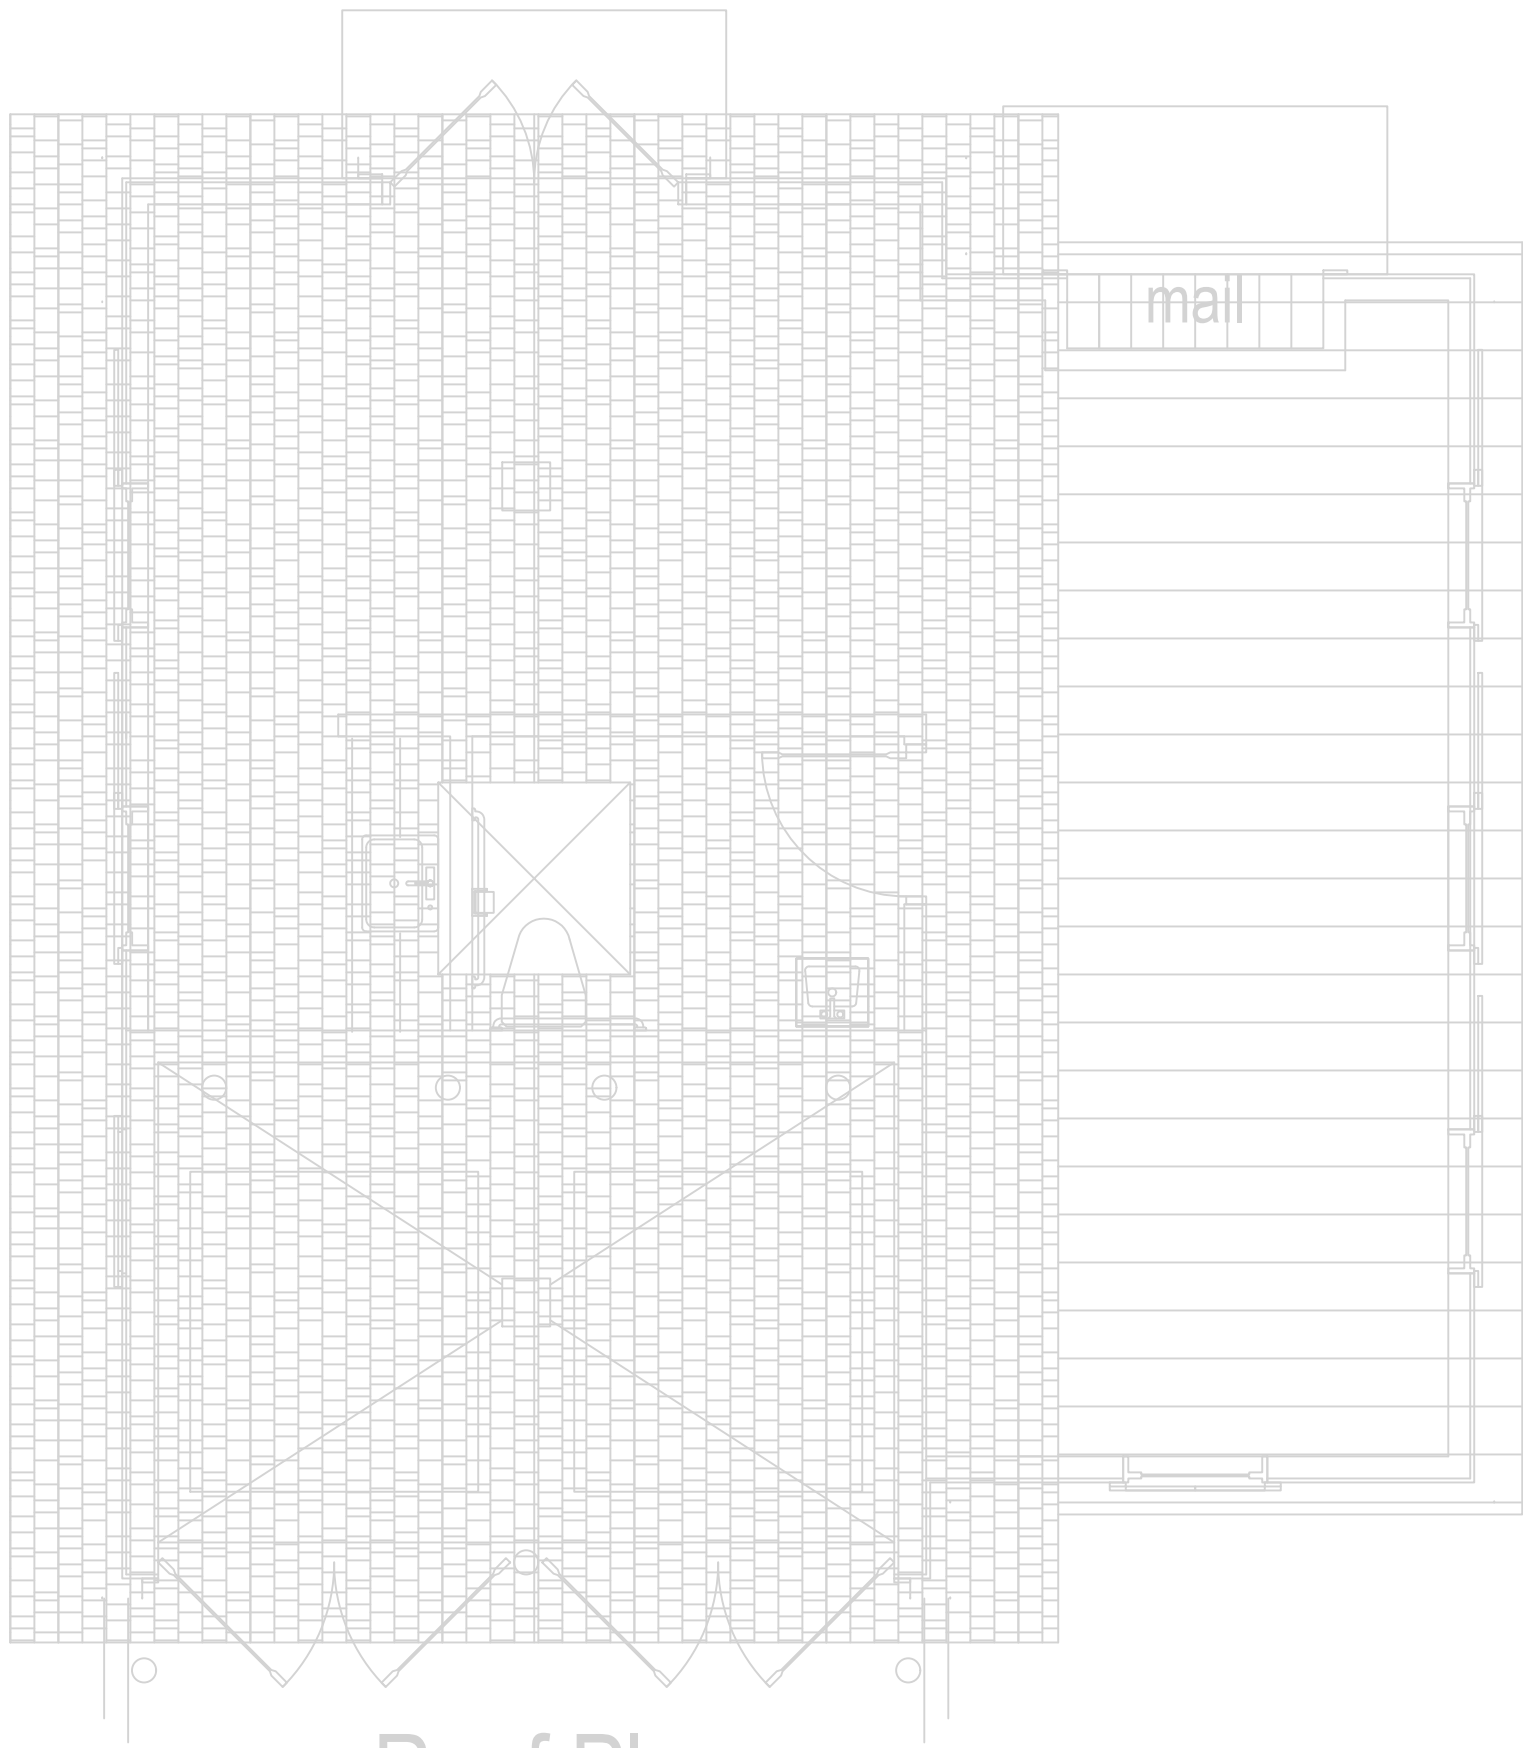


Roof Plan

2

ROOF PLAN - BUILDING 5

SCALE: 1/4"=1'-0"

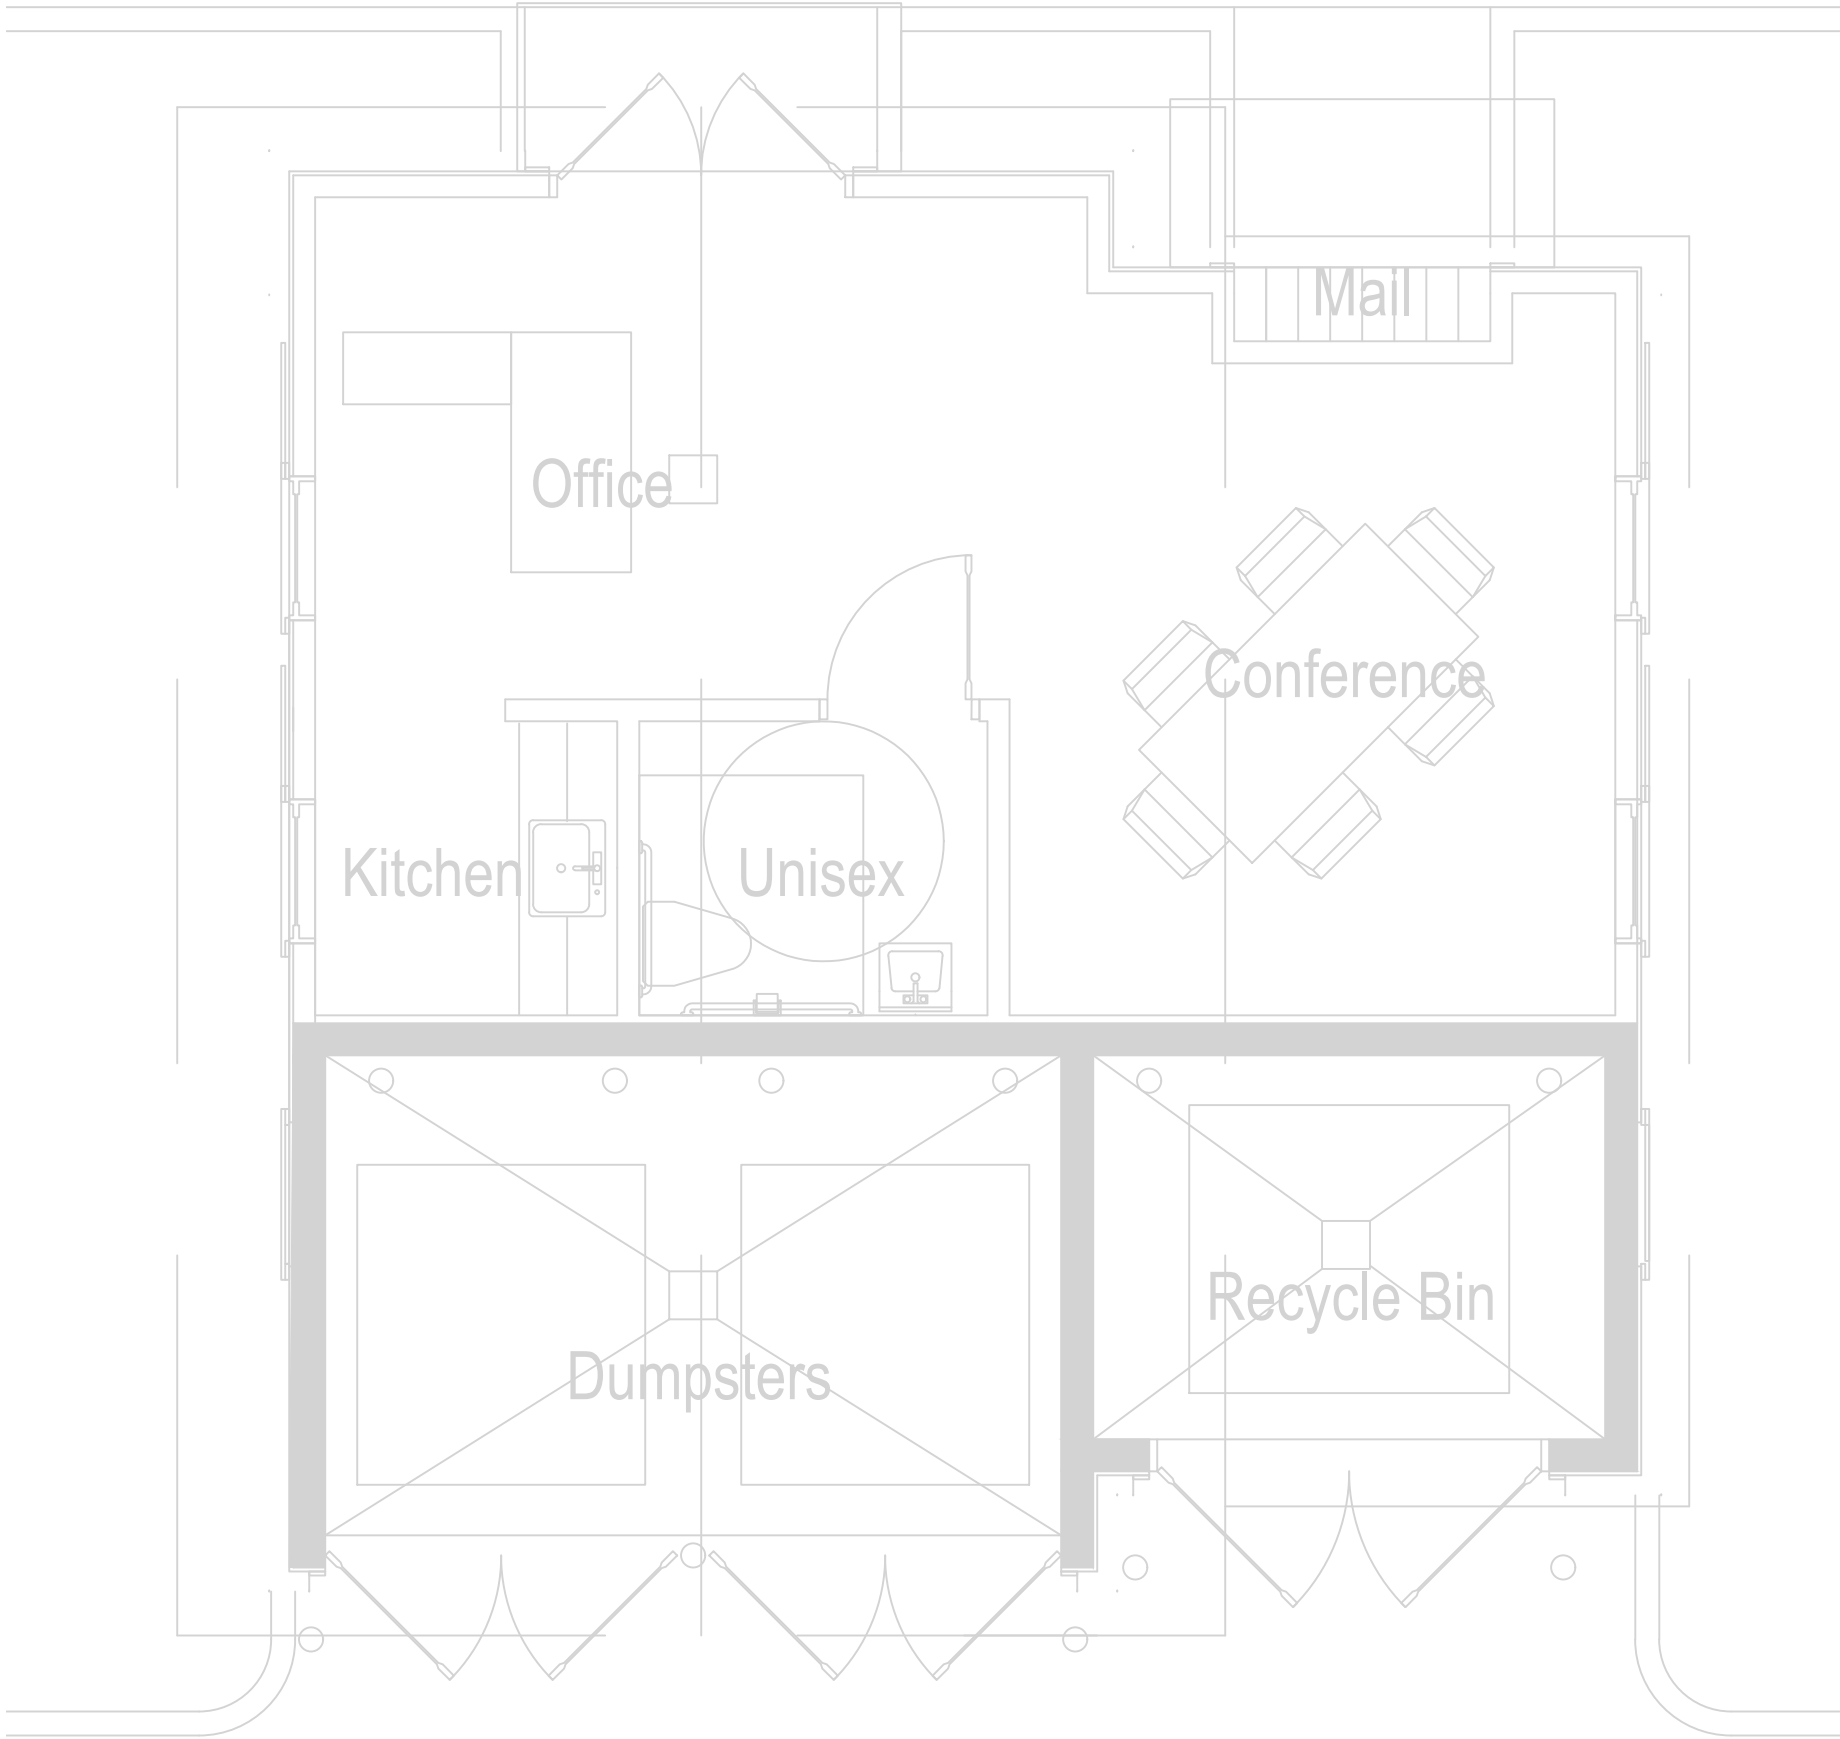

Floor Plan

1

MAIN LEVEL FLOOR PLAN - BUILDING 5

SCALE: 1/4"=1'-0"



Market District

Commercial T5
Buildings 1, 2, 5

Charlotte Drive
Milton, GA

08/25/2019

BRIAN J. FAGAN - PROFESSIONAL ENGINEER
GA LICENSE NUM: 32550 - EXP: 12/31/2018



Design Professional

Issue Date

08/19/2019



Date Description

0

08/26/2019 PRELIMINARY REVIEW

Project Name

Strawberry Fields

Project Number

17027-02

Drawn by

CH / BJF

Designed by

BJF

Checked by


BJF

Plumbing Floor Plan

Description

Sheet Number

P2.0

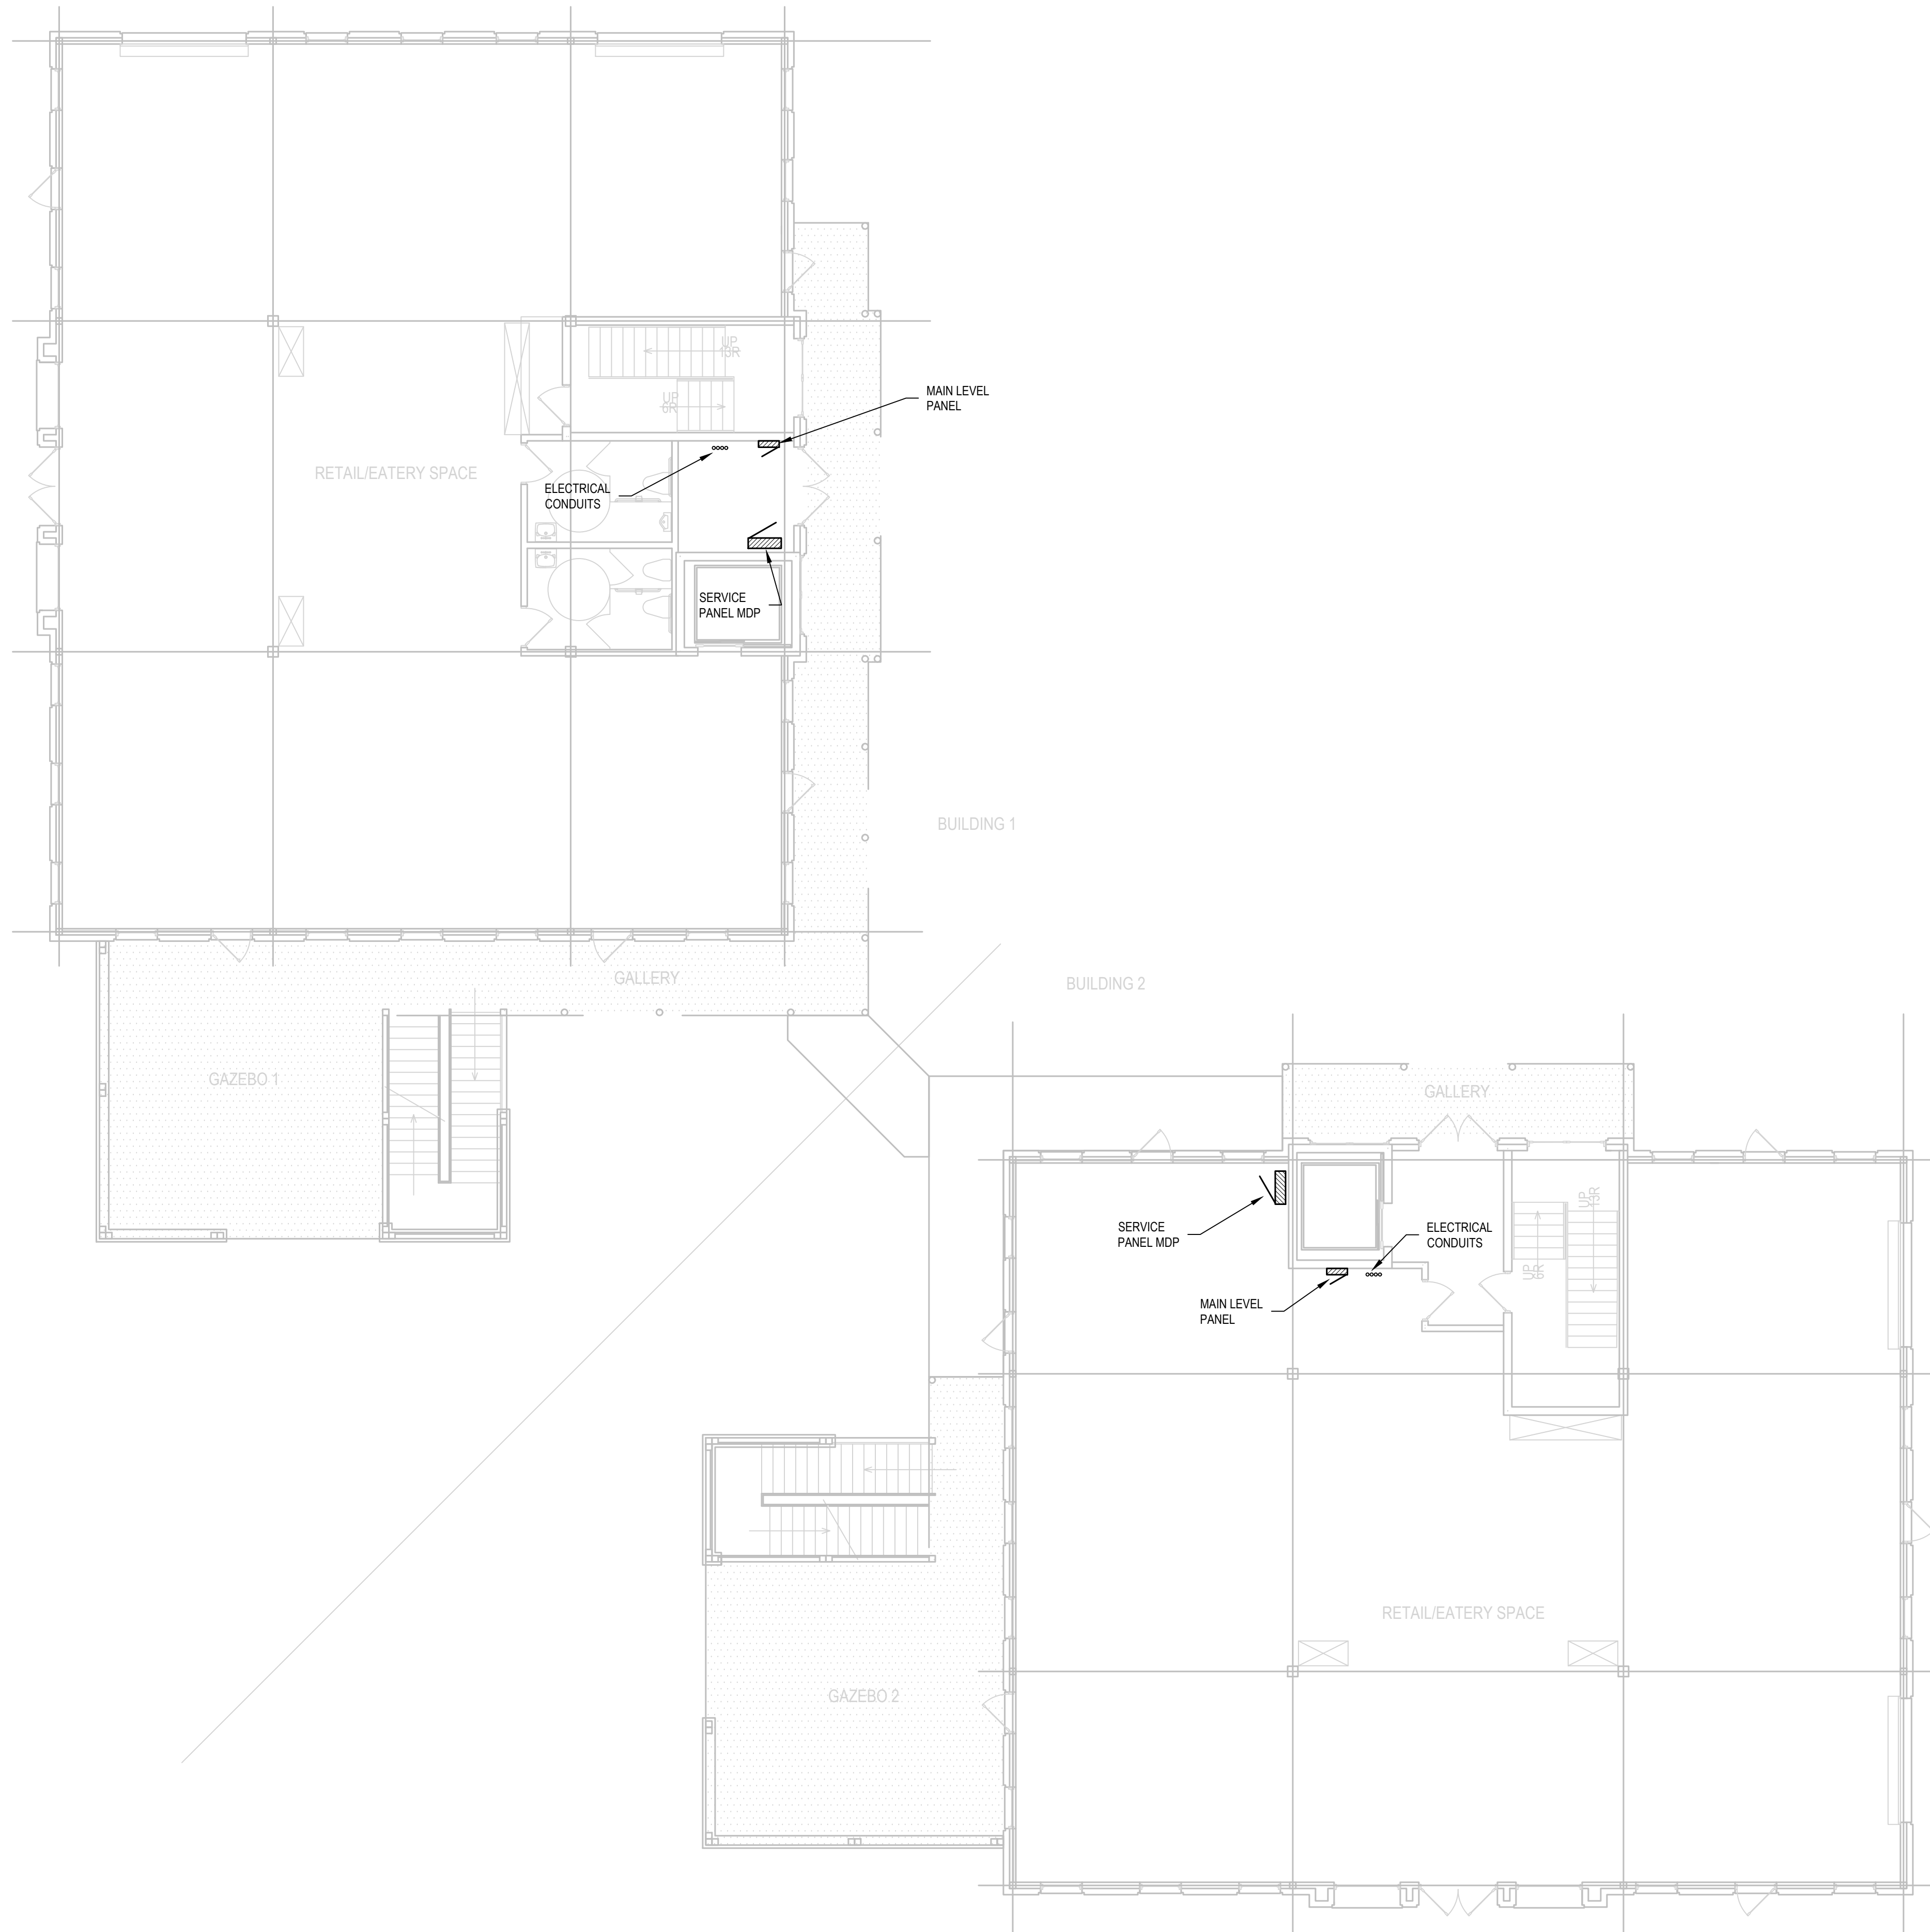

1 MAIN LEVEL FLOOR PLAN
SCALE: 1/8"=1'-0"



Market District

Commercial T5
Buildings 1, 2, 5

Charlotte Drive
Milton, GA

08/25/2019

BRIAN J. FAGAN - PROFESSIONAL ENGINEER
GA LICENSE NUM: 32550 - EXP: 12/31/2018



Design Professional

Issue Date 08/19/2019

▶	Date	Description
0	08/26/2019	PRELIMINARY REVIEW

Project Name Strawberry Fields

Project Number 17027-02

Drawn by CH / B/JF

Designed by B/JF

Checked by B/JF

Electrical Floor Plan

Description

Sheet Number

E1.1



1 2ND LEVEL FLOOR PLAN
SCALE: 1/8"=1'-0"



Market District

Commercial T5
Buildings 1, 2, 5

Charlotte Drive
Milton, GA

08/25/2019

BRIAN J. FAGAN - PROFESSIONAL ENGINEER
GA LICENSE NUM: 32550 - EXP: 12/31/2018



Design Professional

Issue Date **08/19/2019**

▷	Date	Description
0	08/26/2019	PRELIMINARY REVIEW

Project Name **Strawberry Fields**

Project Number **17027-02**

Drawn by **CH / BJF**

Designed by **BJF**

Checked by **BJF**

Electrical Floor Plan

Description

Sheet Number

E1.2



Market District

Commercial T5
Buildings 1, 2, 5

Charlotte Drive
Milton, GA

08/25/2019

BRIAN J. FAGAN - PROFESSIONAL ENGINEER
GA LICENSE NUM: 32550 - EXP: 12/31/2018



Design Professional

Issue Date 08/19/2019

▶	Date	Description
0	08/26/2019	PRELIMINARY REVIEW

Project Name Strawberry Fields

Project Number 17027-02

Drawn by CH / B/JF

Designed by B/JF


Checked by B/JF

Electrical Floor Plan

Description

Sheet Number

E1.3

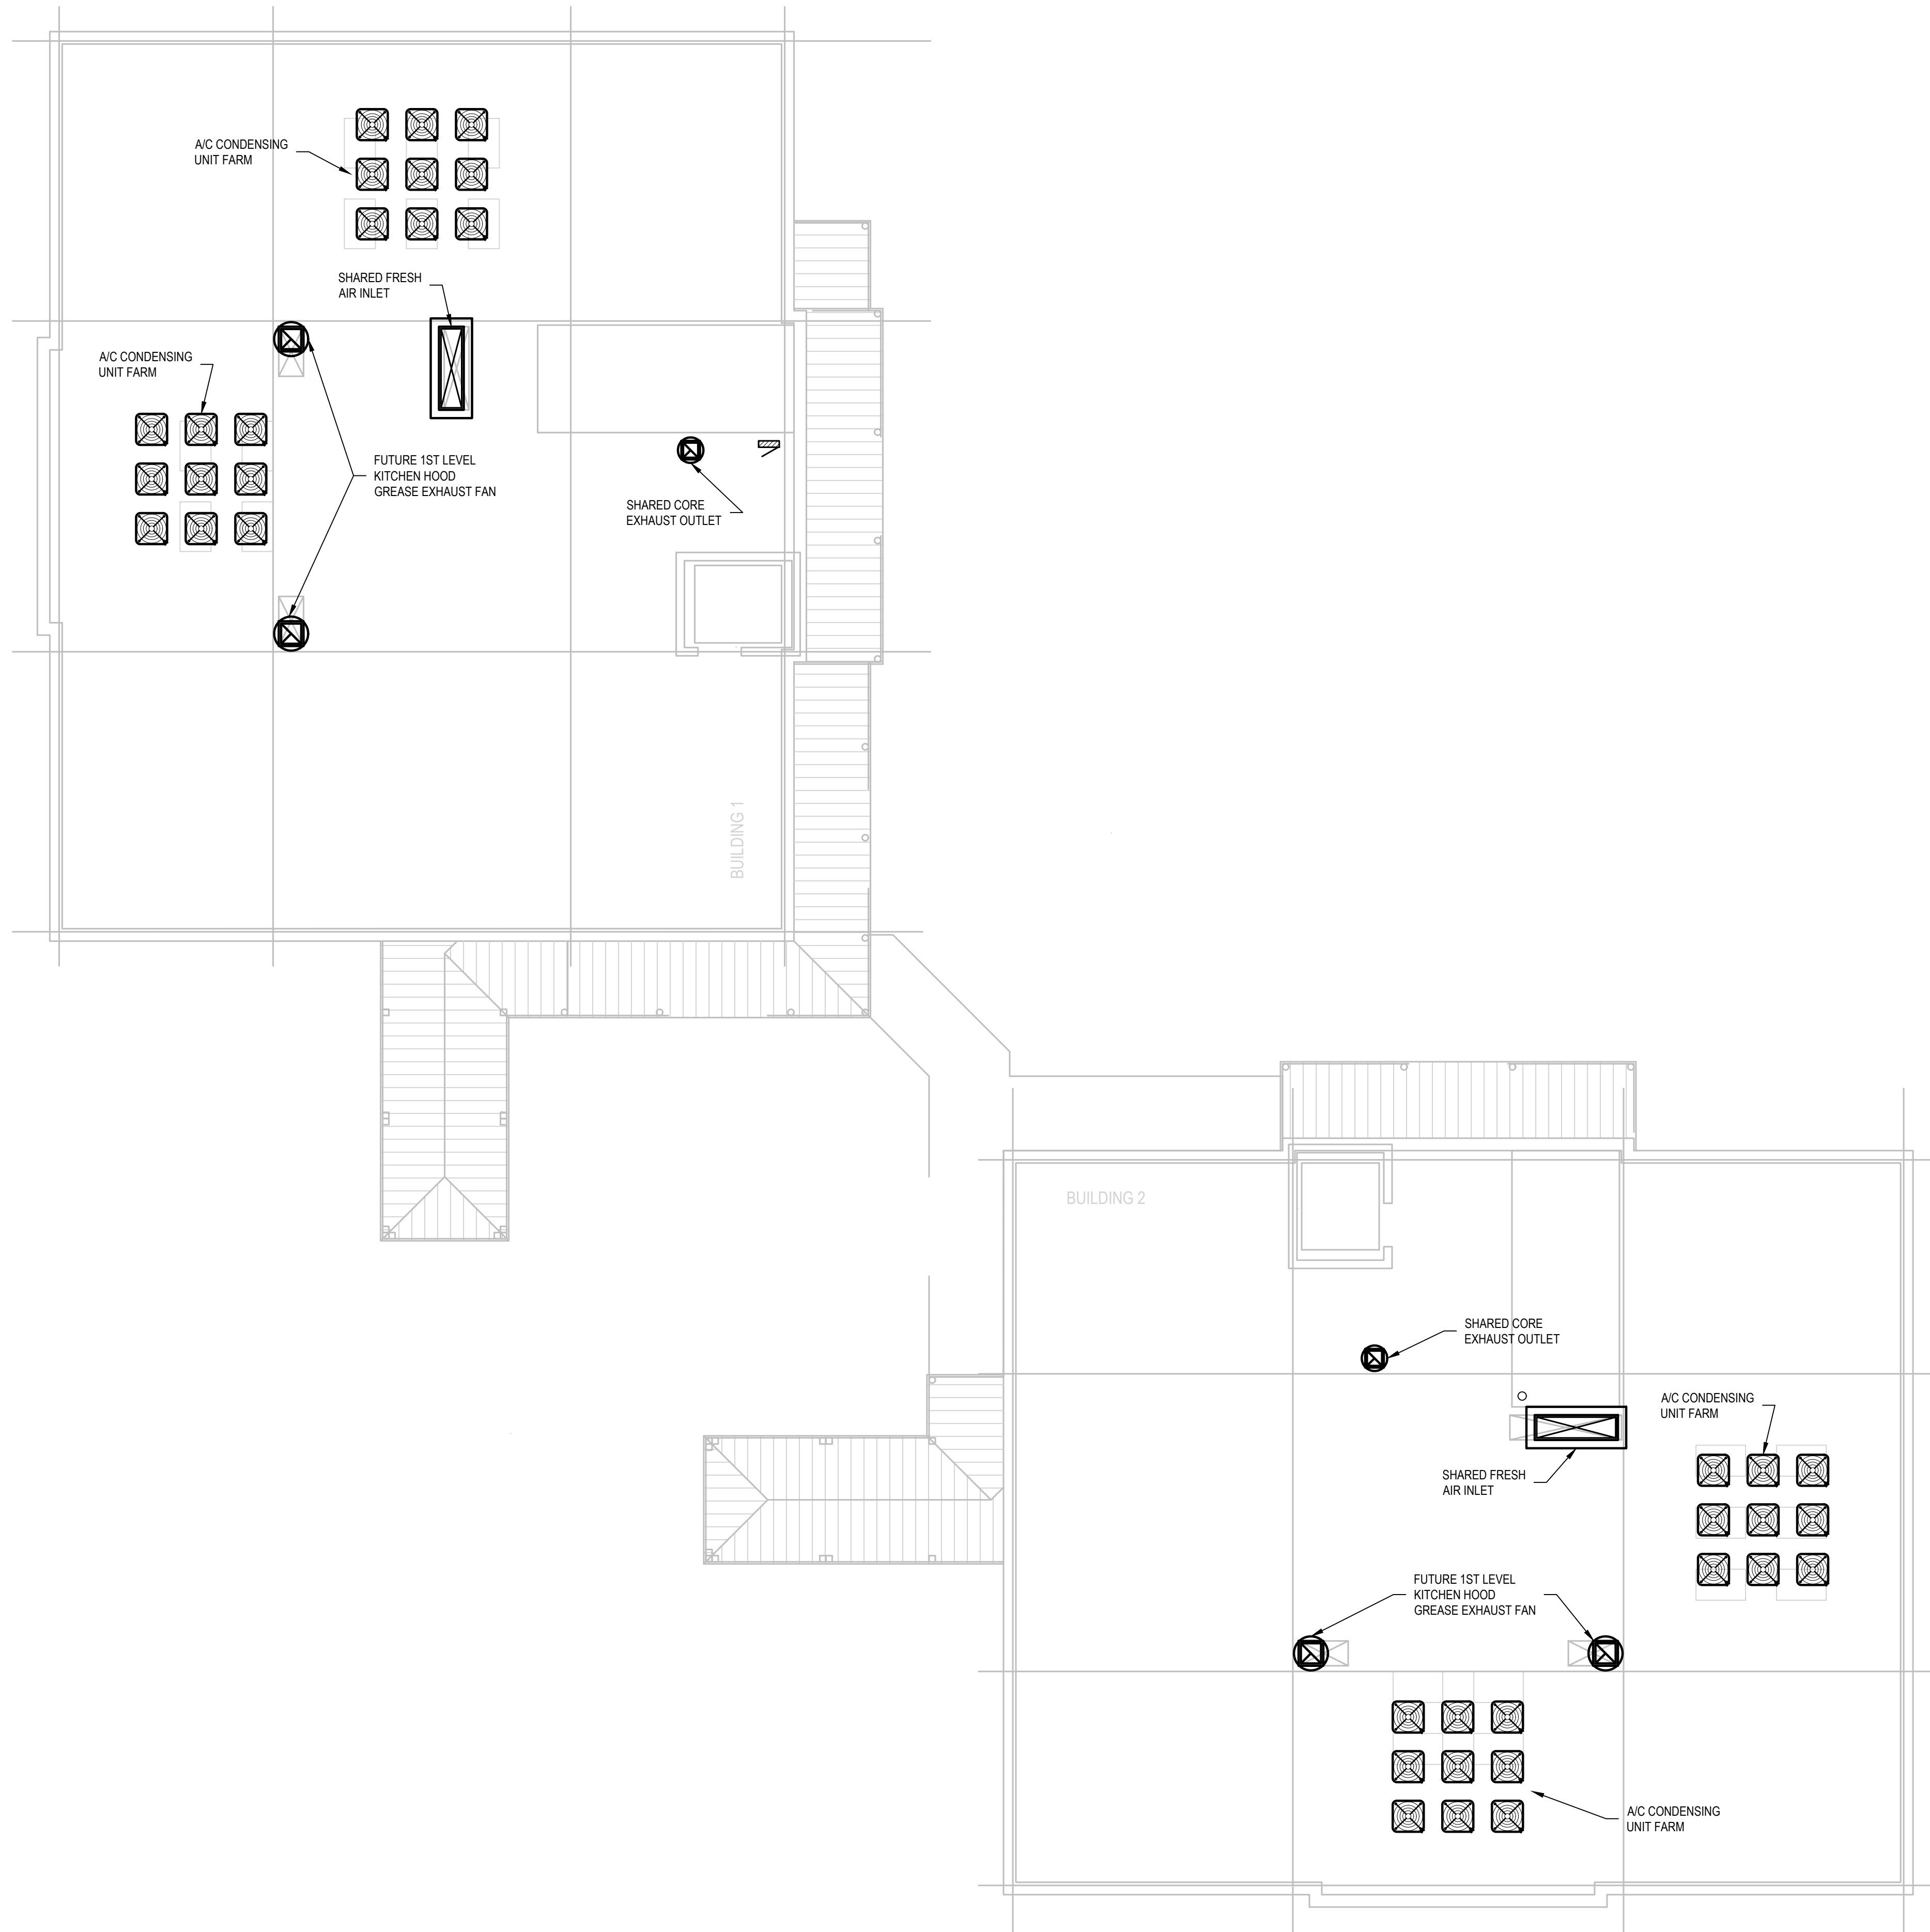

1 ROOF TERRACE LEVEL FLOOR PLAN
SCALE: 1/8"=1'-0"



Market District

Commercial T5
Buildings 1, 2, 5

Charlotte Drive
Milton, GA

08/25/2019

BRIAN J. FAGAN - PROFESSIONAL ENGINEER
GA LICENSE NUM: 32550 - EXP: 12/31/2018



Design Professional

Issue Date **08/19/2019**

▶	Date	Description
0	08/26/2019	PRELIMINARY REVIEW

Project Name **Strawberry Fields**

Project Number **17027-02**

Drawn by **CH / BJF**


Designed by **BJF**

Checked by **BJF**

Electrical Floor Plan

Description

Sheet Number **E1.4**

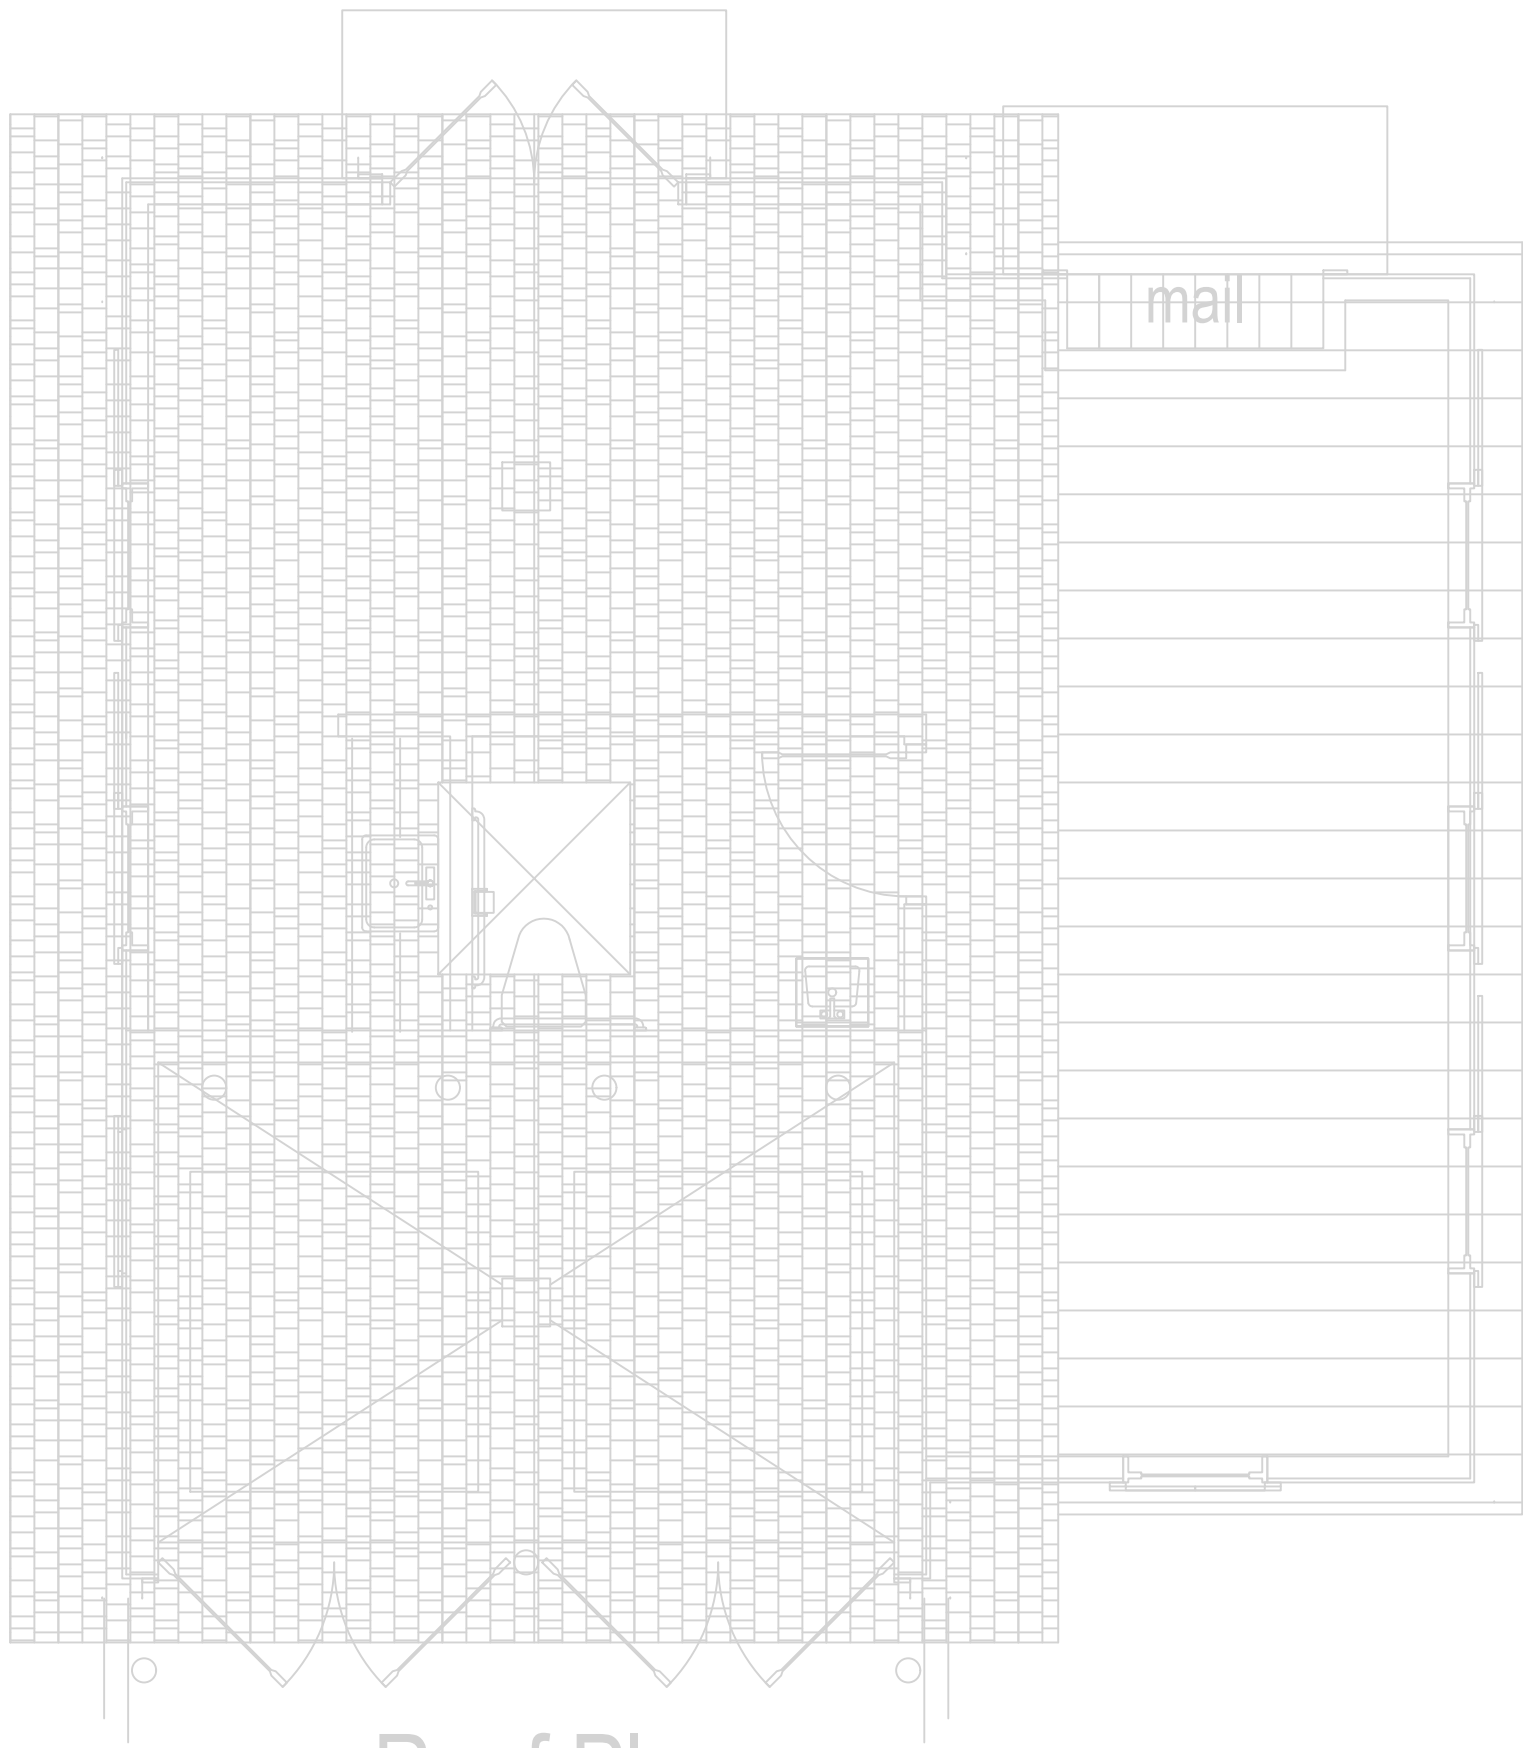


Roof Plan

2

ROOF PLAN - BUILDING 5

SCALE: 1/4"=1'-0"

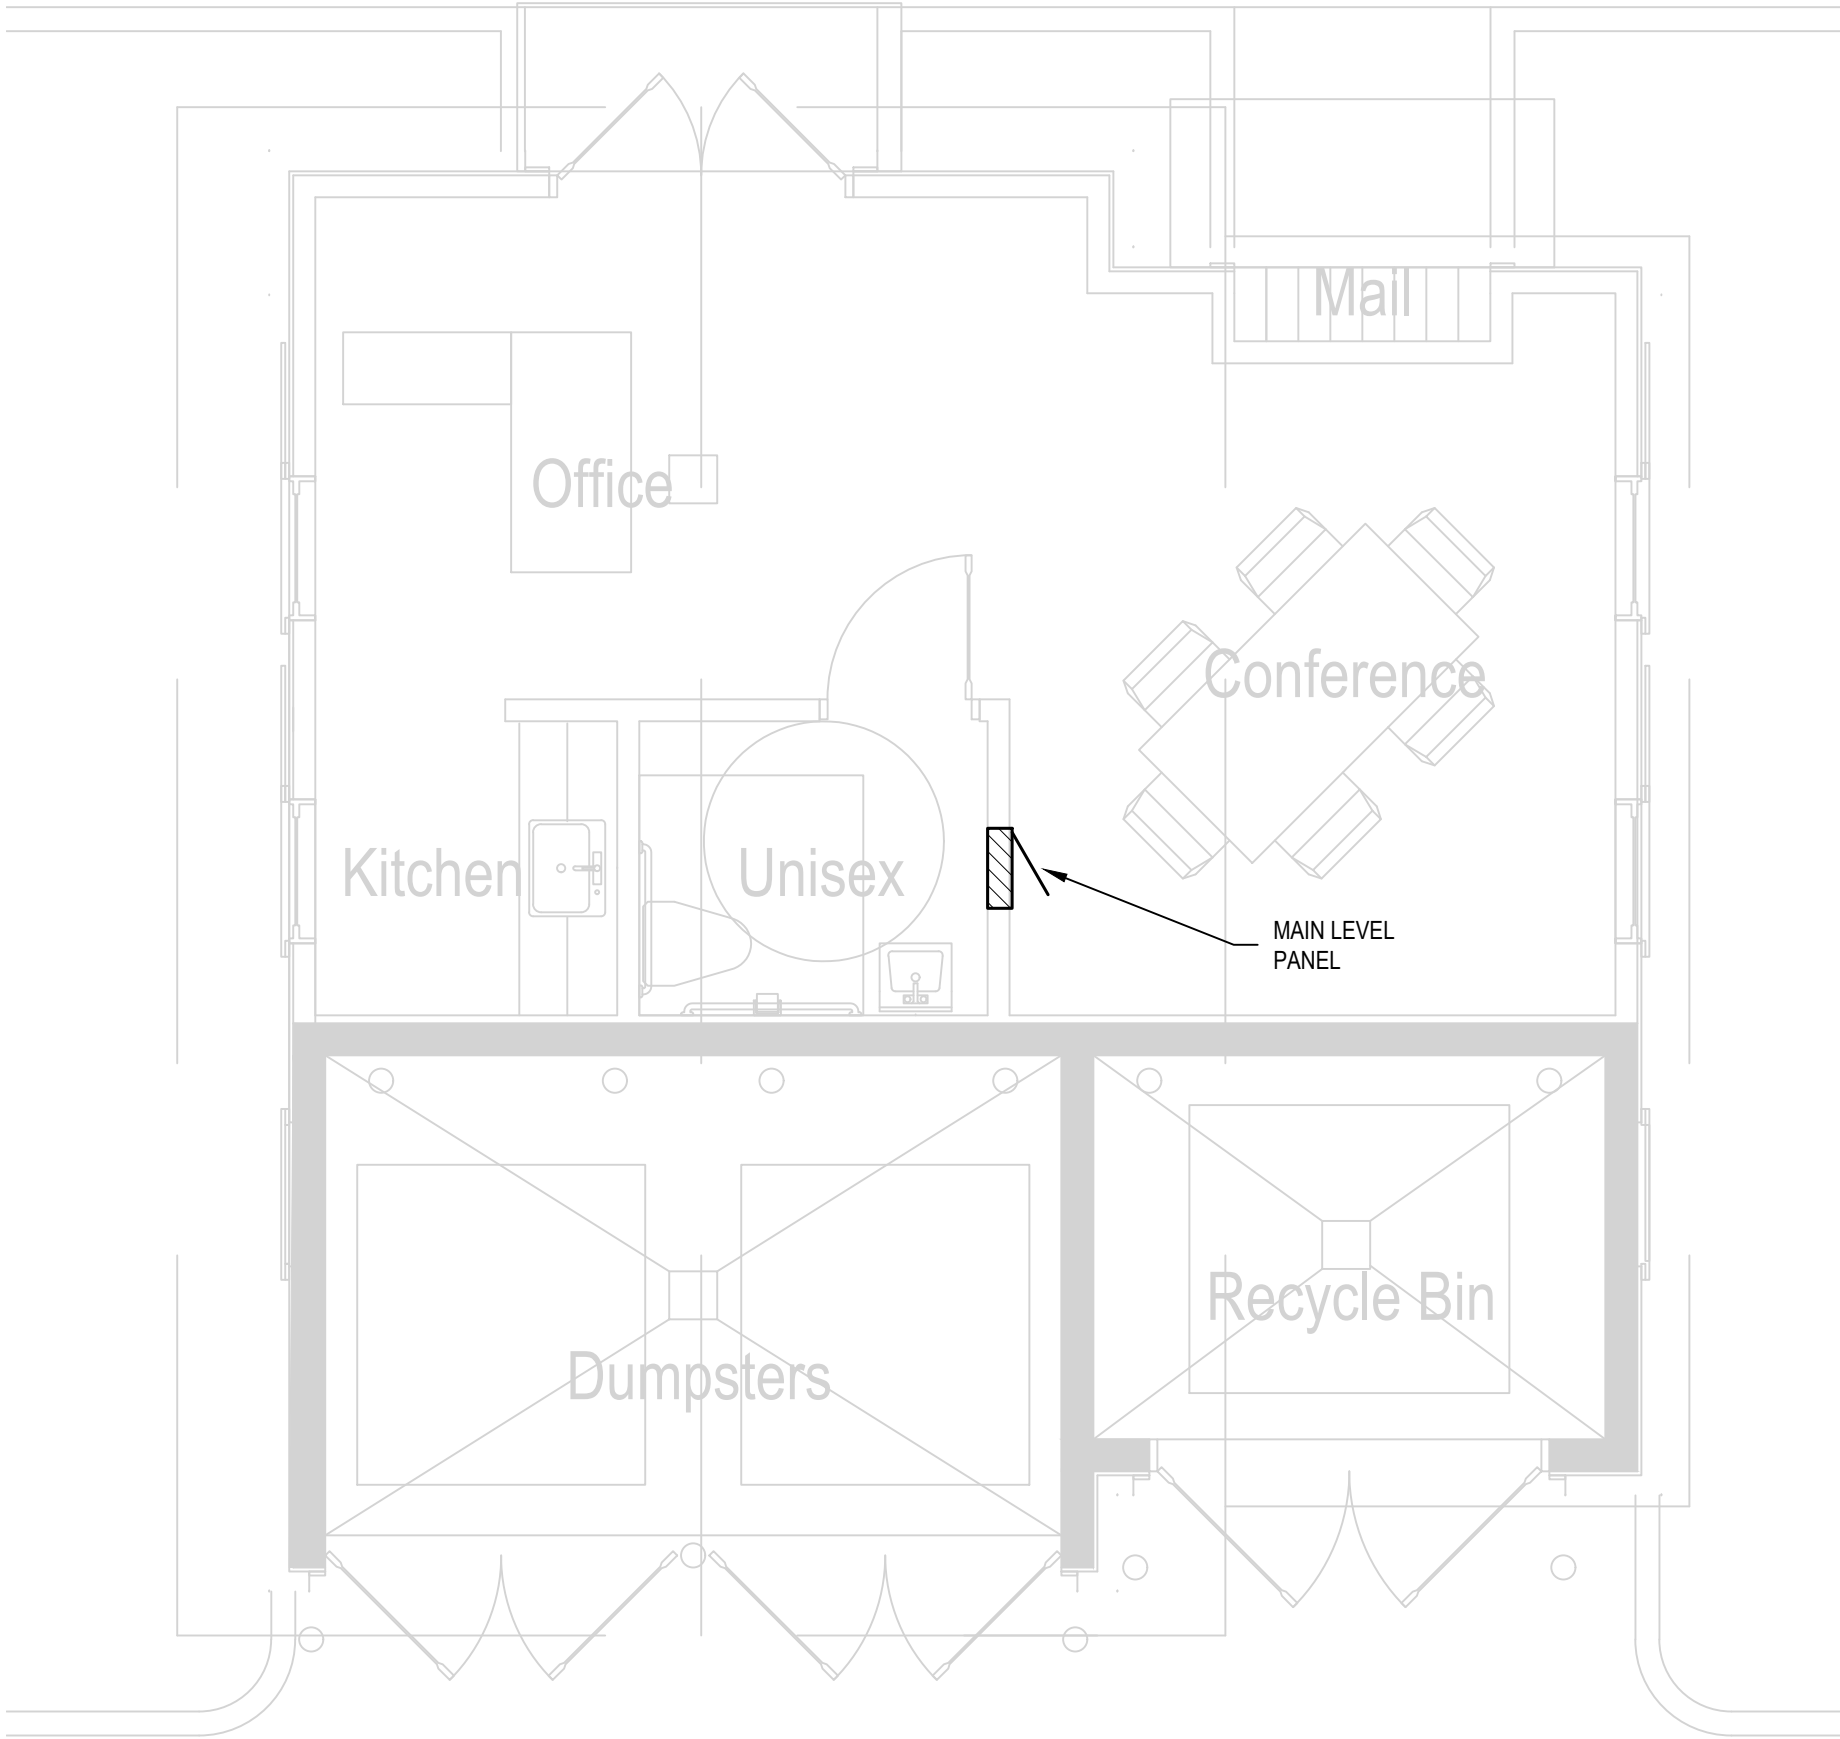

Floor Plan

1

MAIN LEVEL FLOOR PLAN - BUILDING 5

SCALE: 1/4"=1'-0"



Market District

Commercial T5
Buildings 1, 2, 5

Charlotte Drive
Milton, GA

08/25/2019

BRIAN J. FAGAN - PROFESSIONAL ENGINEER
GA LICENSE NUM: 32550 - EXP: 12/31/2018



Design Professional

Issue Date 08/19/2019

▶	Date	Description
0	08/26/2019	PRELIMINARY REVIEW

Project Name Strawberry Fields

Project Number 17027-02

Drawn by CH / BJF

Designed by BJF

Checked by BJF

Electrical Floor Plan

Description

Sheet Number

E2.0