

L1	S 00°17'35" E	11.96'
L2	S 39°58'32" W	39.83'
L3	S 23°42'23" W	42.28'
L4	N 00°36'04" W	50.79'
L5	N 00°34'18" W	43.28'

Scale: 1" = 30'

0 30 60

- 1/2" = 12" RIGHT OF WAY MON.
- TEMP. BENCH MARK
- DRAIN MANHOLE
- DROP INLET
- CATCH BASIN
- DRAIN
- CANOPY SUPPORT
- SEWER MANHOLE
- SEWER CLEANOUT
- SEWER BLOWOUT VALVE
- SEWER
- POWER POLE
- POWER POLE & GUY
- POWER DROP
- POWER TRANSFORMER
- POWER JUNCTION BOX
- POWER LIGHT PEDES
- ELECTRIC
- GAS METER
- GAS VALVE
- GAS VENT
- GAS
- TELEPHONE MANHOLE
- TELEPHONE PEDESTAL
- TELE. CROSS CON. BOX
- TELEPHONE
- CABLE
- WATER METER
- WATER VALVE
- FIRE HYDRANT
- WATER
- TRAFFIC CONTROL BOX
- TRAFFIC LIGHT POLE
- CONTOUR
- ELEVATION
- FENCE
- FLAG POLE
- MAILBOX
- ORNAMENTAL LIGHT
- SIGN
- TREE

CSRS
CONSTRUCTION SURVEYING & RECORDS, INC.

CSRS, Inc.
6707 Parkview Road, Suite 200, Baton Rouge, LA 70806
Phone: 225-769-0545 Fax: 225-767-0000
www.csrsinc.com

Exhibit

SHOWING

Site Plan

OF

Tract C-1

Located in
SECTION 21
T-9-S R-3-E
GREENSBURG LAND DISTRICT
ASCENSION PARISH
LOUISIANA

Butch Ingram


Date: MAY 2001

Project Number: 250710

Drawn By: G.

Checked By: T.

Shaw

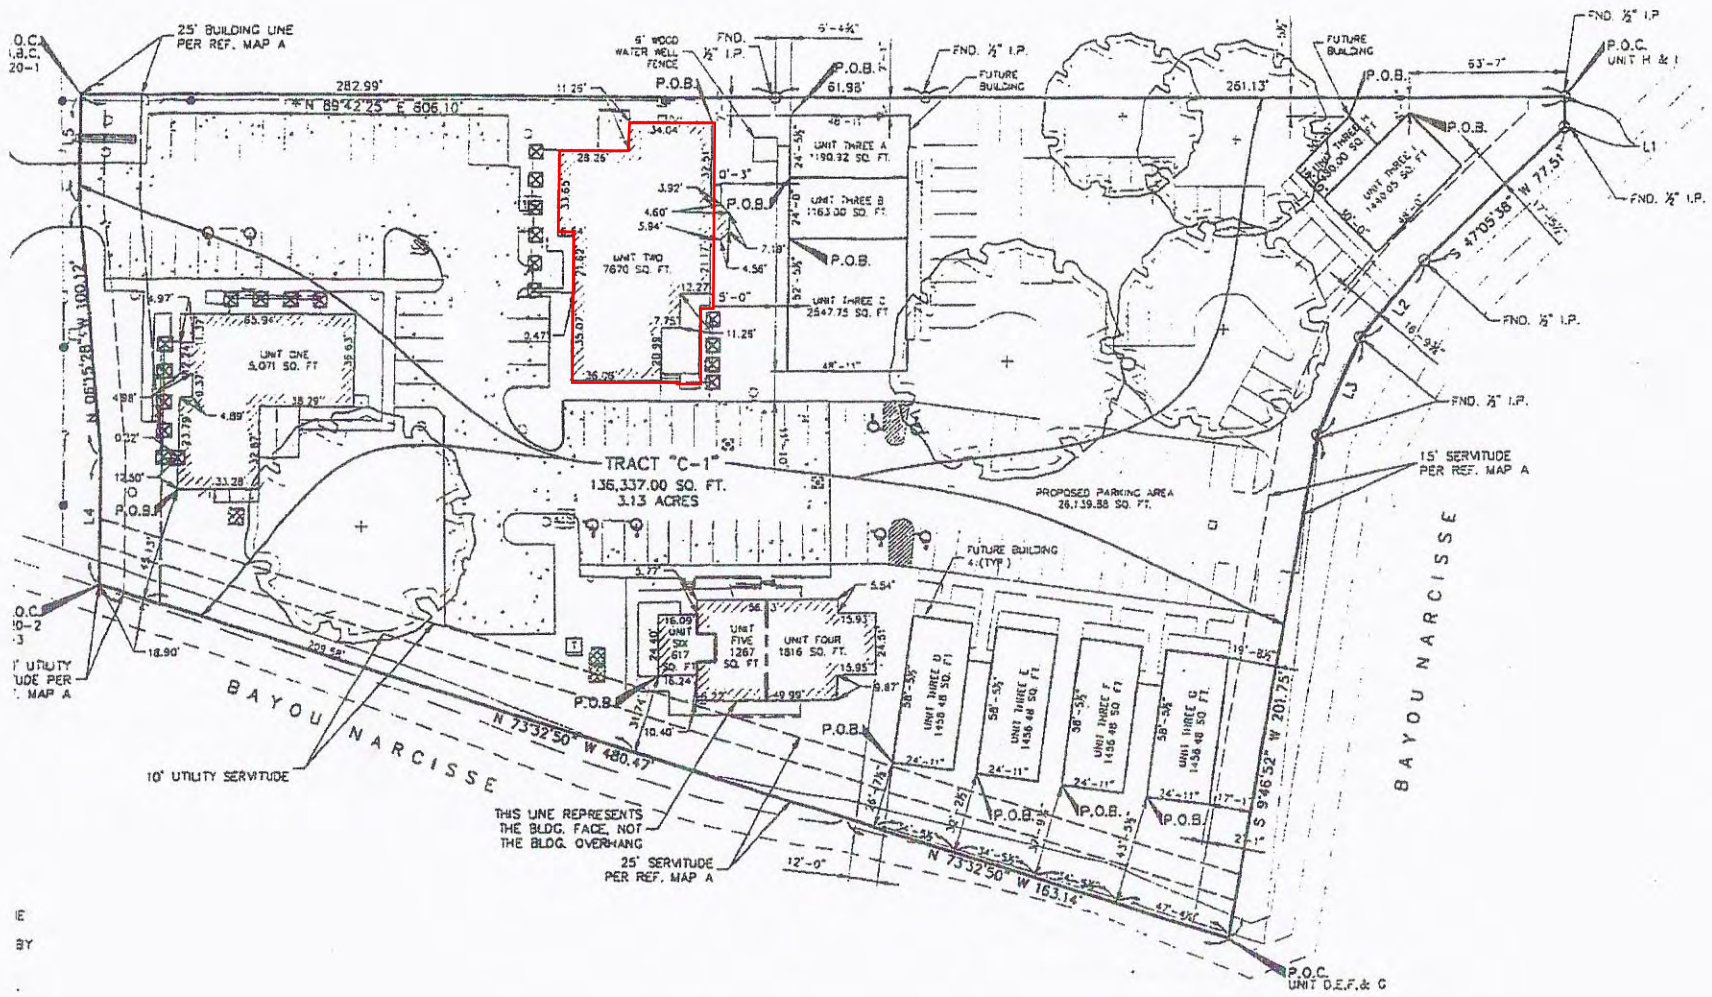

E
BY
REF
IONS,
THE