


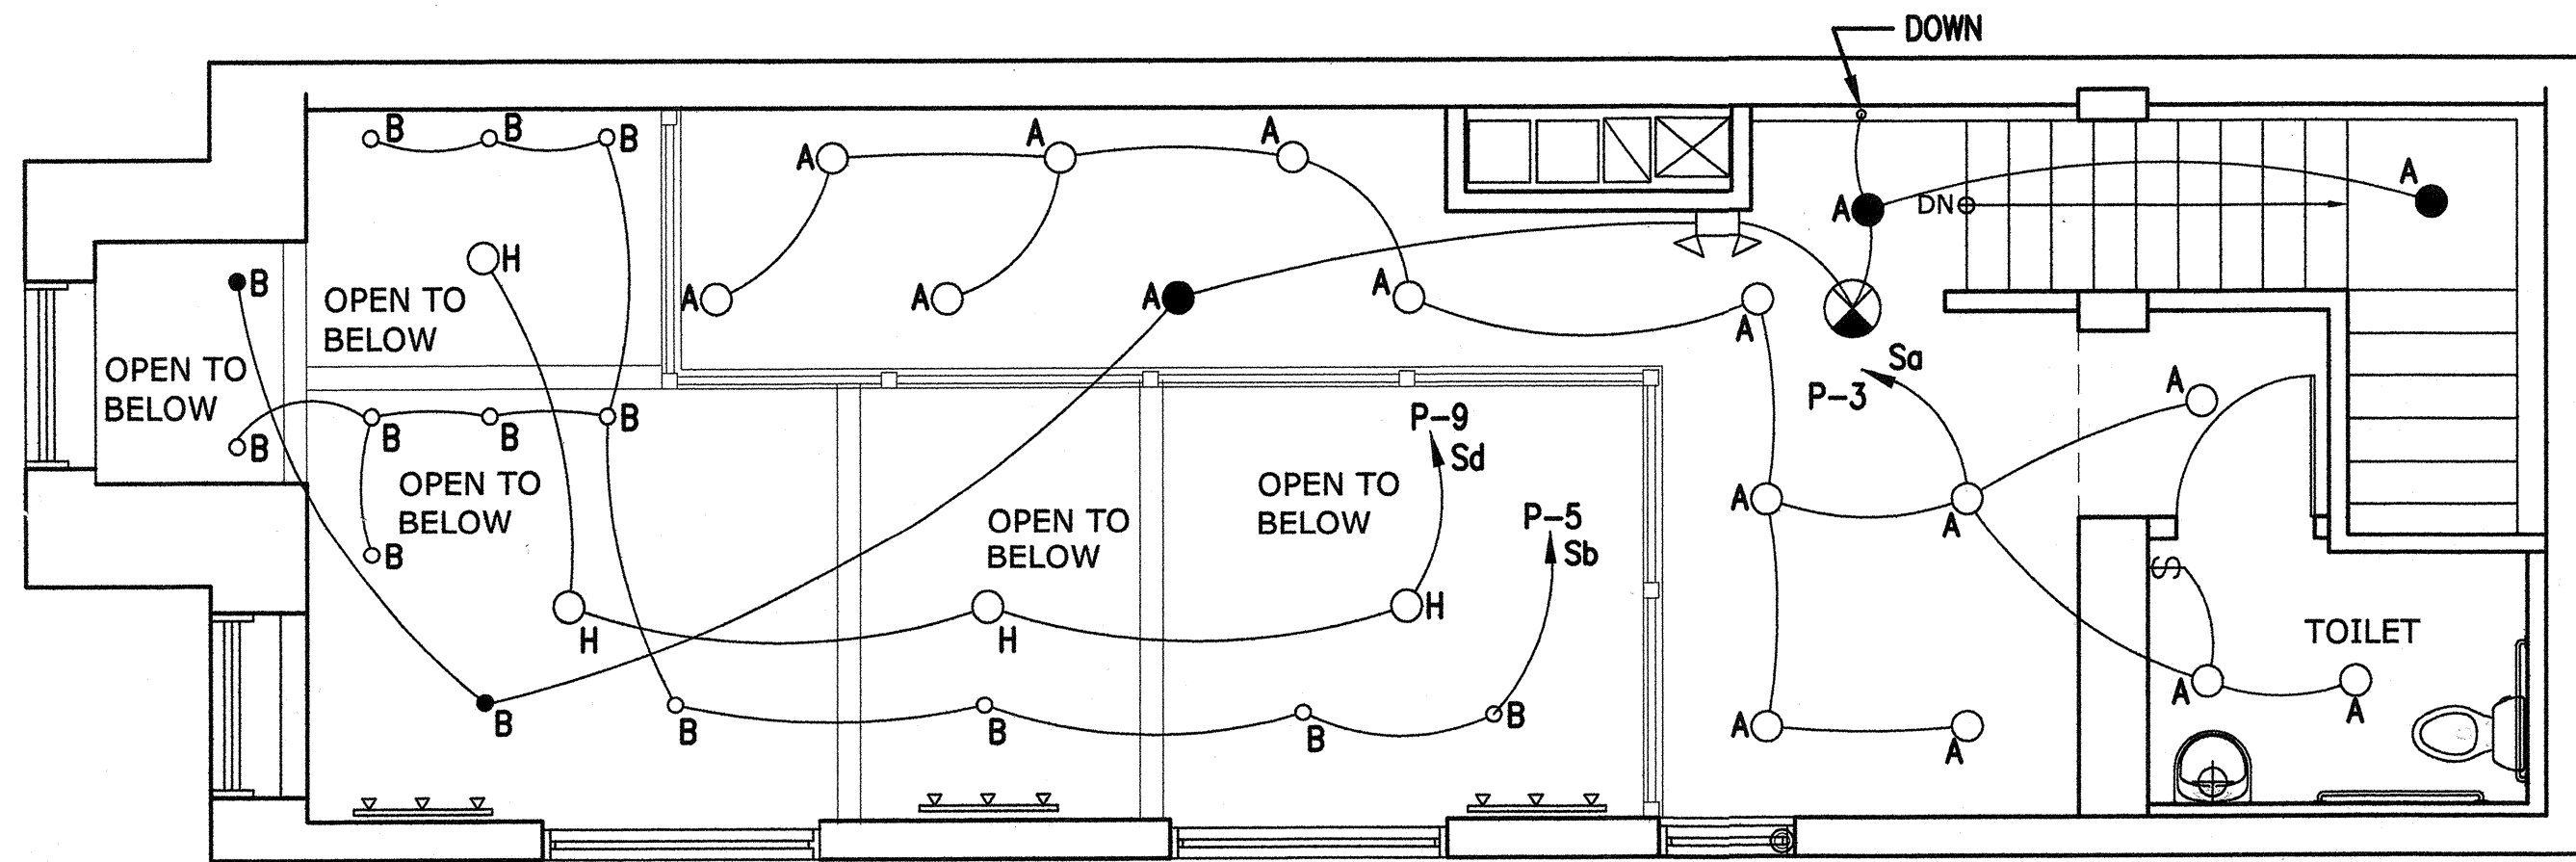


LIGHTING FIXTURE SCHEDULE					
TYPE	BASIS OF DESIGN OR APPROVED EQUAL	VOLTS	LAMPS	MOUNTING	REMARKS/NOTES
A	OPEN REFLECTOR 6" DIA, RECESSED DOWN LIGHT - DIMMING	120	1-32 WATT DTT	RECESSED	GENERAL LIGHTING
B	SUSPENDED DOWN LIGHT - DIMMING	120	2-32 WATT DTT	SURFACE	GENERAL LIGHTING
C	ENCLOSED RECESSED DOWN LIGHT - DIMMING	120	1-32 WATT DTT	RECESSED	PREP. AREA
D	SUSPENDED ACCENT LIGHT - DIMMING	120	1-MR16 30 WATT FLOOD	SUSPENDED	BAR AREA
E	2'x4' RECESSED TROFFER, K-12 PRISMATIC VIRGIN ACRYLIC LENS	120	3-F32T5 3500K	RECESSED	PREP. AREA
F	VANITY LIGHT OVER MIRROR	120	-	WALL MOUNTED	TOILET
G	ACCENT LIGHT, AREA LIGHT	120	-	WALL MOUNTED	AREA LIGHT
H	CEILING FAN	120	-	SUSPENDED	FAN
J	ACCENT LIGHT, AREA LIGHT. SEE NOTE BELOW	120	-	WALL MOUNTED	AREA LIGHT
⊗	LITHONIA #LKSBI/3R ELN	120	(LED LAMPS - FURNISHED)	CEILING/WALL	EXIT LIGHT
⚡	LITHONIA #ELM3	120	(FURNISHED)	WALL MTD	EMERG. LIGHT

NOTE 1: THE TYPE J LIGHTING FIXTURE IS SPECIFIED WITH INTEGRAL EMERGENCY POWER BATTERY, BATTERY CHARGER AND AUTOMATIC TRANSFER SWITCH TO PROVIDE EMERGENCY LIGHTING

MEZZANINE - LIGHTING PLAN - 2ND FLOOR


SCALE: 1/4" = 1'-0"

DIMMER WALL SWITCHES Sa AND Sb, TO CONTROL TYPE A AND TYPE B LIGHTING FIXTURES AND WALL SWITCHES Sc AND Sd TO CONTROL EXTERIOR LIGHTS AND THE CEILING FANS.

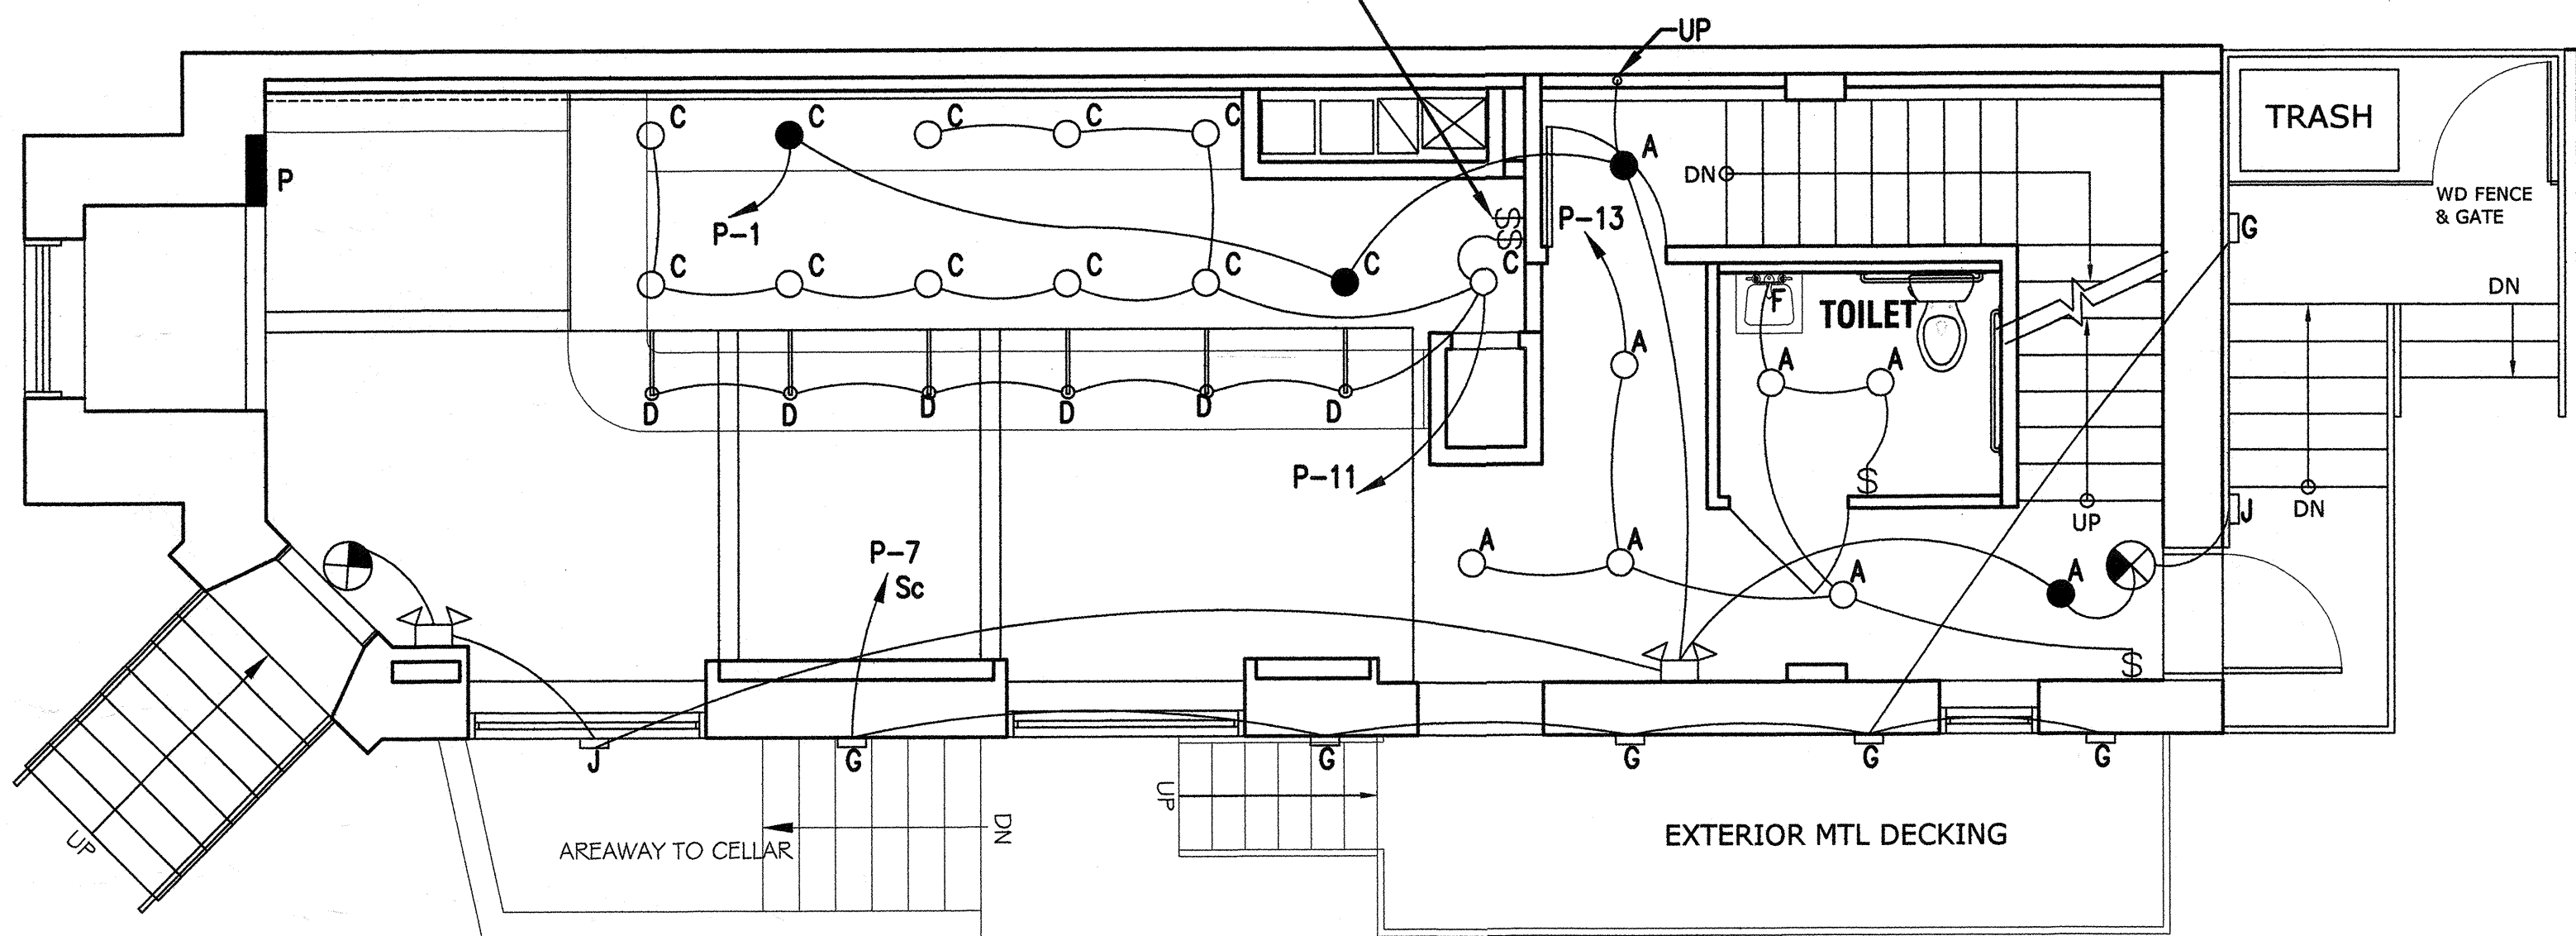

FIRST FLOOR - LIGHTING PLAN

SCALE: 1/4" = 1'-0"

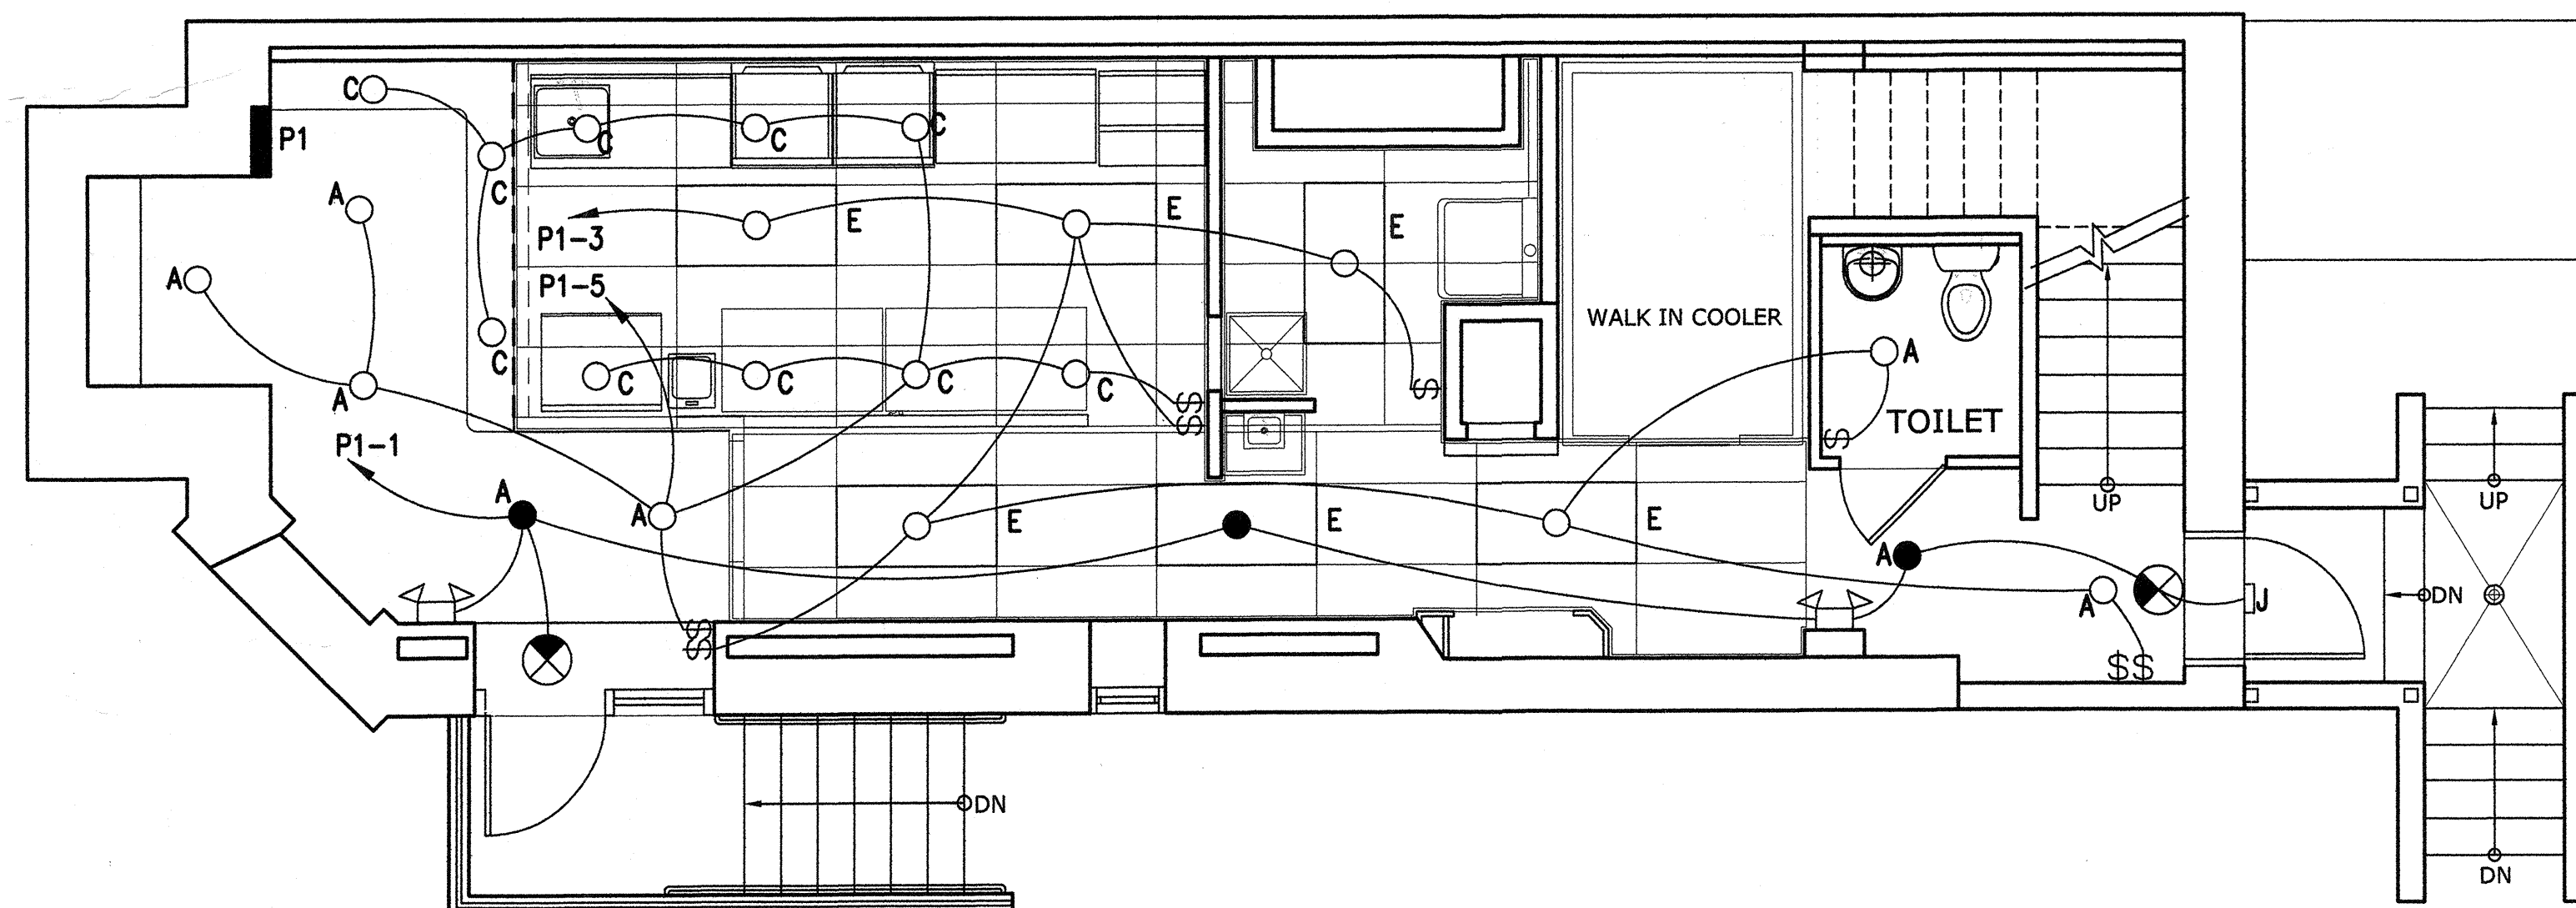

CELLAR LEVEL - KITCHEN - LIGHTING PLAN

SCALE: 1/4" = 1'-0"

SYMBOLS LIST

- ⊗ A FLUORESCENT LIGHTING FIXTURE. FIXTURE TYPE A IS INDICATED. REFER TO LIGHTING FIXTURE SCHEDULE
- ⊗ EXIT LIGHT. DARKENED QUADRANT DENOTES FACE OF UNIT. PROVIDE DIRECTIONAL ARROWS AS INDICATED
- ⚡ EMERGENCY EGRESS LIGHT, WALL MOUNTED
- NIGHT LIGHT FIXTURE. SWITCHED AT PANEL BOARD
- \$ WALL SWITCH, 20A, 120/277 VOLTS, 48 INCHES AFF
- \$3 THREE WAY WALL SWITCH
- \$M MANUAL MOTOR STARTER/DISCONNECT WITH O/C HEATERS
- ⊕ CONVENIENCE OUTLET, NEMA 5-20R, 18 INCHES AFF
- ⊕ G CONVENIENCE OUTLET, 42" AFF WITH GROUND FAULT INTERRUPTER
- ⊕ NEMA 6-30 RECEPTACLE FOR CONVECTION OVEN
- ⊕ JUNCTION BOX
- ⊕ DISCONNECT SWITCH
- BRANCH CIRCUIT HOME RUN. 2-#12 AWG + 1-#12 AWG GRD
- CONDUIT RUN CONCEALED IN WALL OR CEILING SPACE
- ▨ BRANCH CIRCUIT PANEL BOARD
- AFF ABOVE FINISHED FLOOR
- MCB MAIN CIRCUIT BREAKER
- MLO MAIN LUGS ONLY
- MCA MINIMUM CIRCUIT AMPS
- FLA FULL LOAD AMPS
- GRD GROUNDING CONDUCTOR
- RGS RIGID GALVANIZED STEEL CONDUIT
- ⊕ SD SMOKE DETECTOR, CEILING MOUNTED
- ⊕ F MANUAL PULL STATION, 48" AFF
- ⊕ F HORN LIGHT 90 Db, 80" AFF. NUMBER DENOTES CANDELAS
- ⊕ V VISUAL ANNUNCIATOR. NUMBER DENOTES CANDELAS

REV#1 COMMENTS


NOTED FIRE-LIFE SAFETY
See Cover sheet for: Shop Drawing Records
By *Indur* JUN 04 2013
Fire Protection Division

GOVERNMENT OF THE DISTRICT OF
COLUMBIA PERMIT OPERATIONS DIVISION
Electrical work must conform to the
National Electrical Code
ELECTRICAL ENGINEERING SECTION
JAN 14 2013

ARCHITECTURAL
Design SERVICES, Inc., AIA
architects . planners . interior design
945-B Russell Avenue
Gaithersburg, Maryland 20879
Tel (301) 963.1044
Fax (301) 963.0869
adservices2@covad.net
www.adsarchitects.net

REVISIONS

SEAL

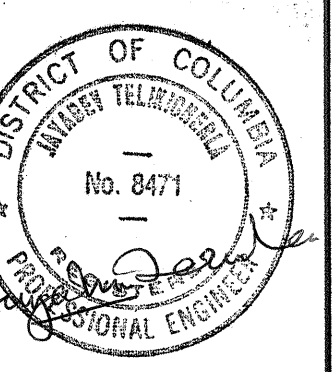

DATE

10/28/2012

SHEET NUMBER

E-2