



REVISIONS		DATE	DESCRIPTION
NO.	DATE	3-18-17	
1			
2			
3			
4			
5			
6			
7			
8			
9			
10			
11			
12			
13			
14			
15			
16			
17			
18			
19			
20			

ROOF PLAN		CHECKED BY #1	CHECKED BY #2	APPROVED BY
DRAWN BY				


CHECKED BY	DESIGNED BY	APPROVED BY
DATE	02/01/2017	
SHEET NUMBER:		
A4		

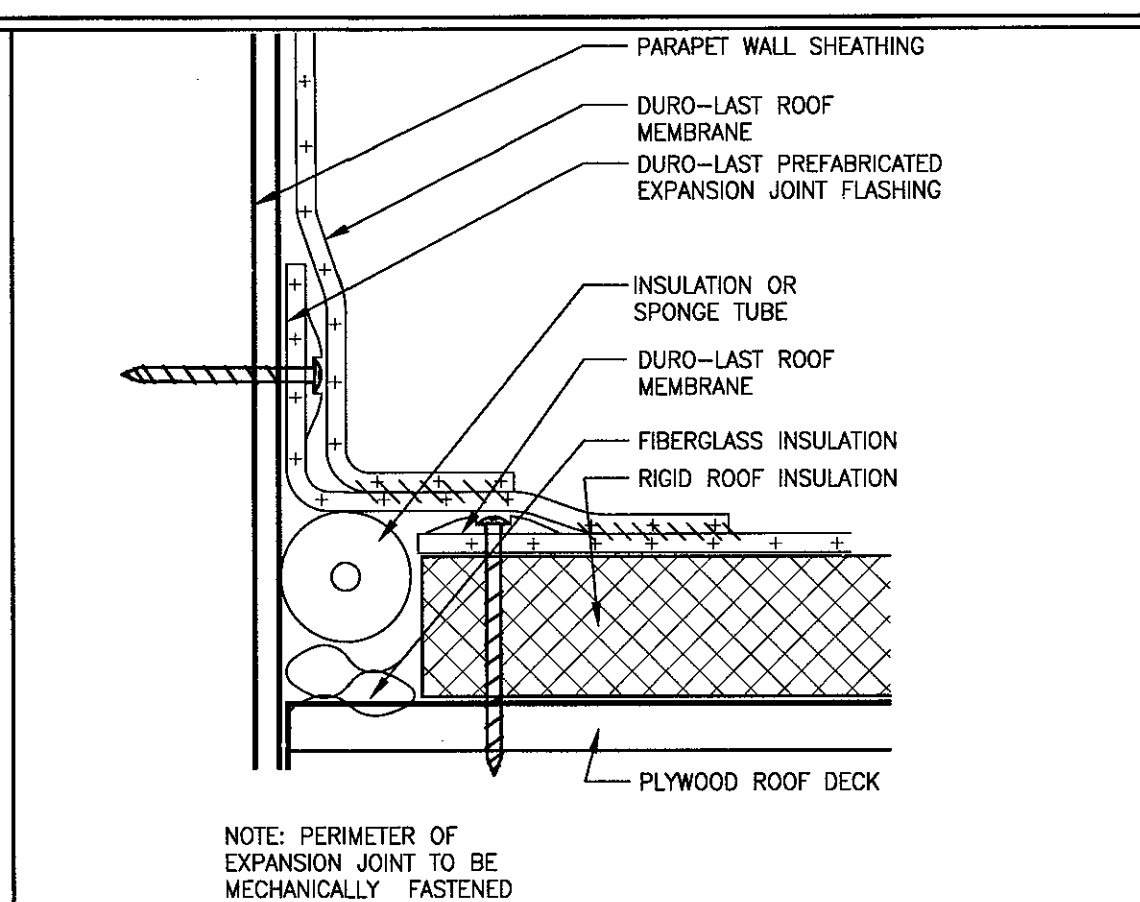


DURO-LAST PARAPET ROOF DETAIL
SCALE: 1
N.T.S.

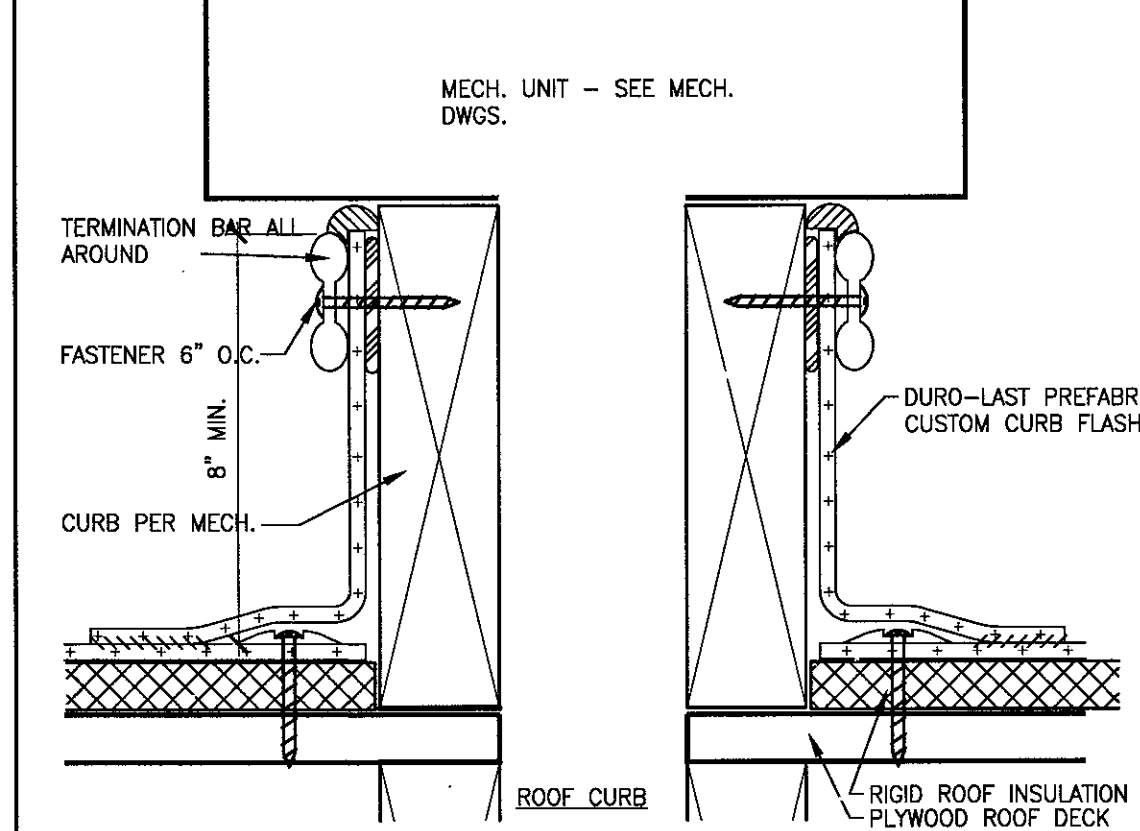


ROOF CURB
SCALE: 2
N.T.S.

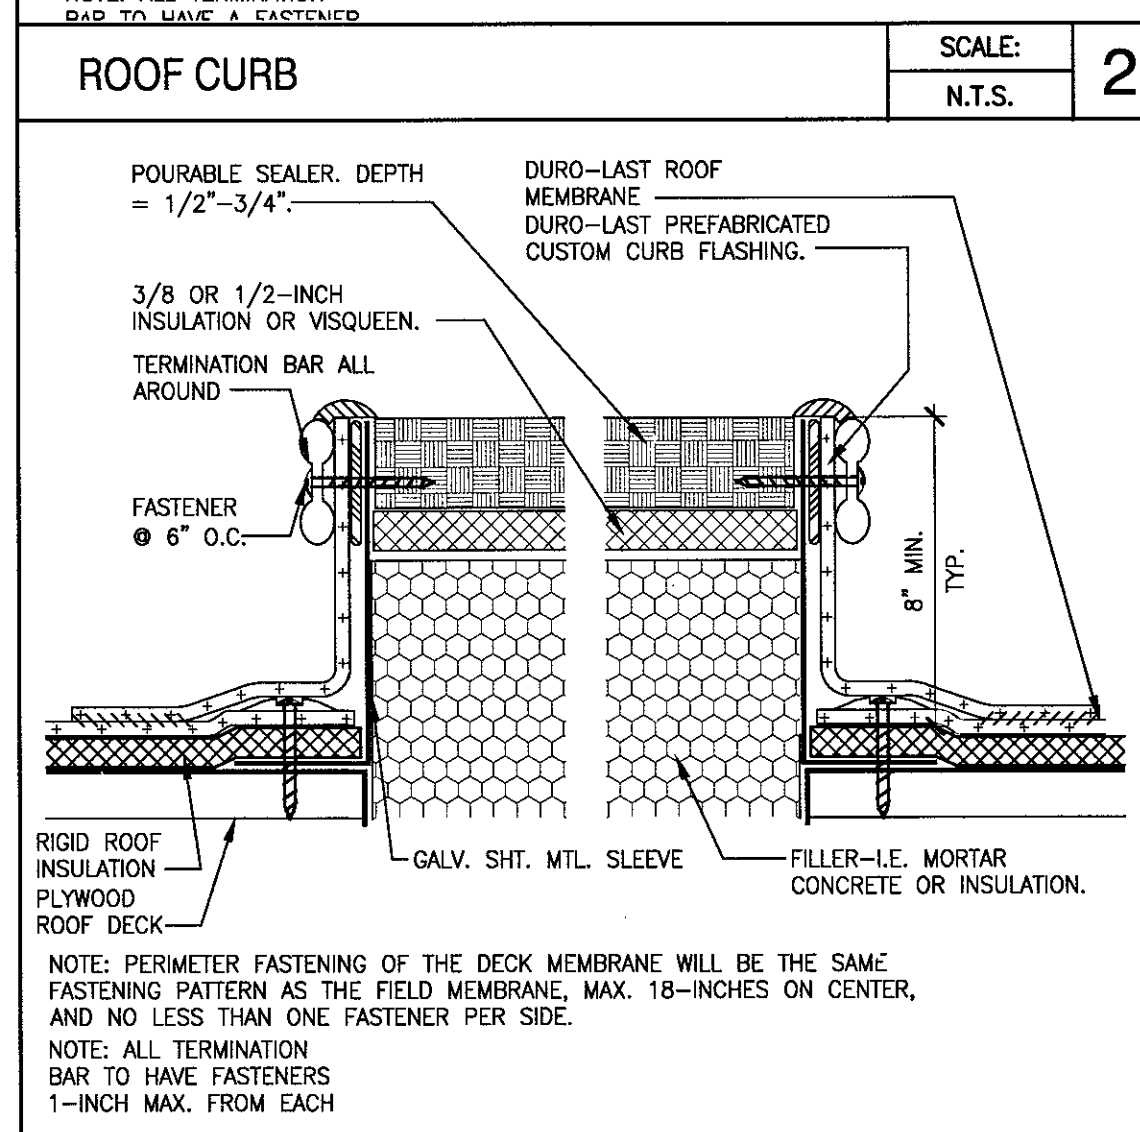


PITCH POCKET
SCALE: 3
N.T.S.

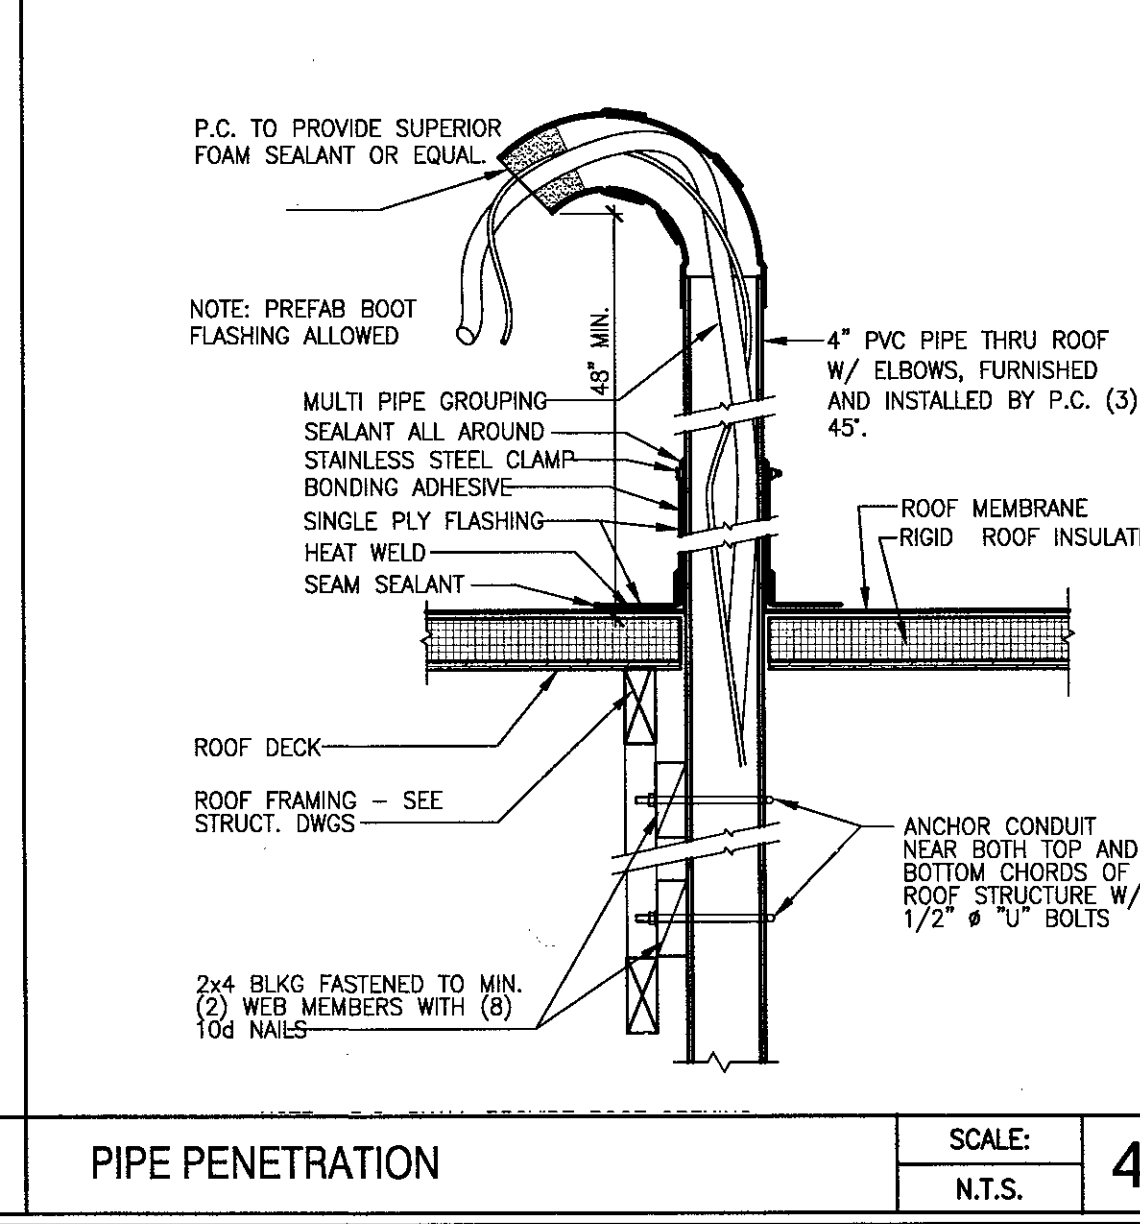


PIPE PENETRATION
SCALE: 4
N.T.S.

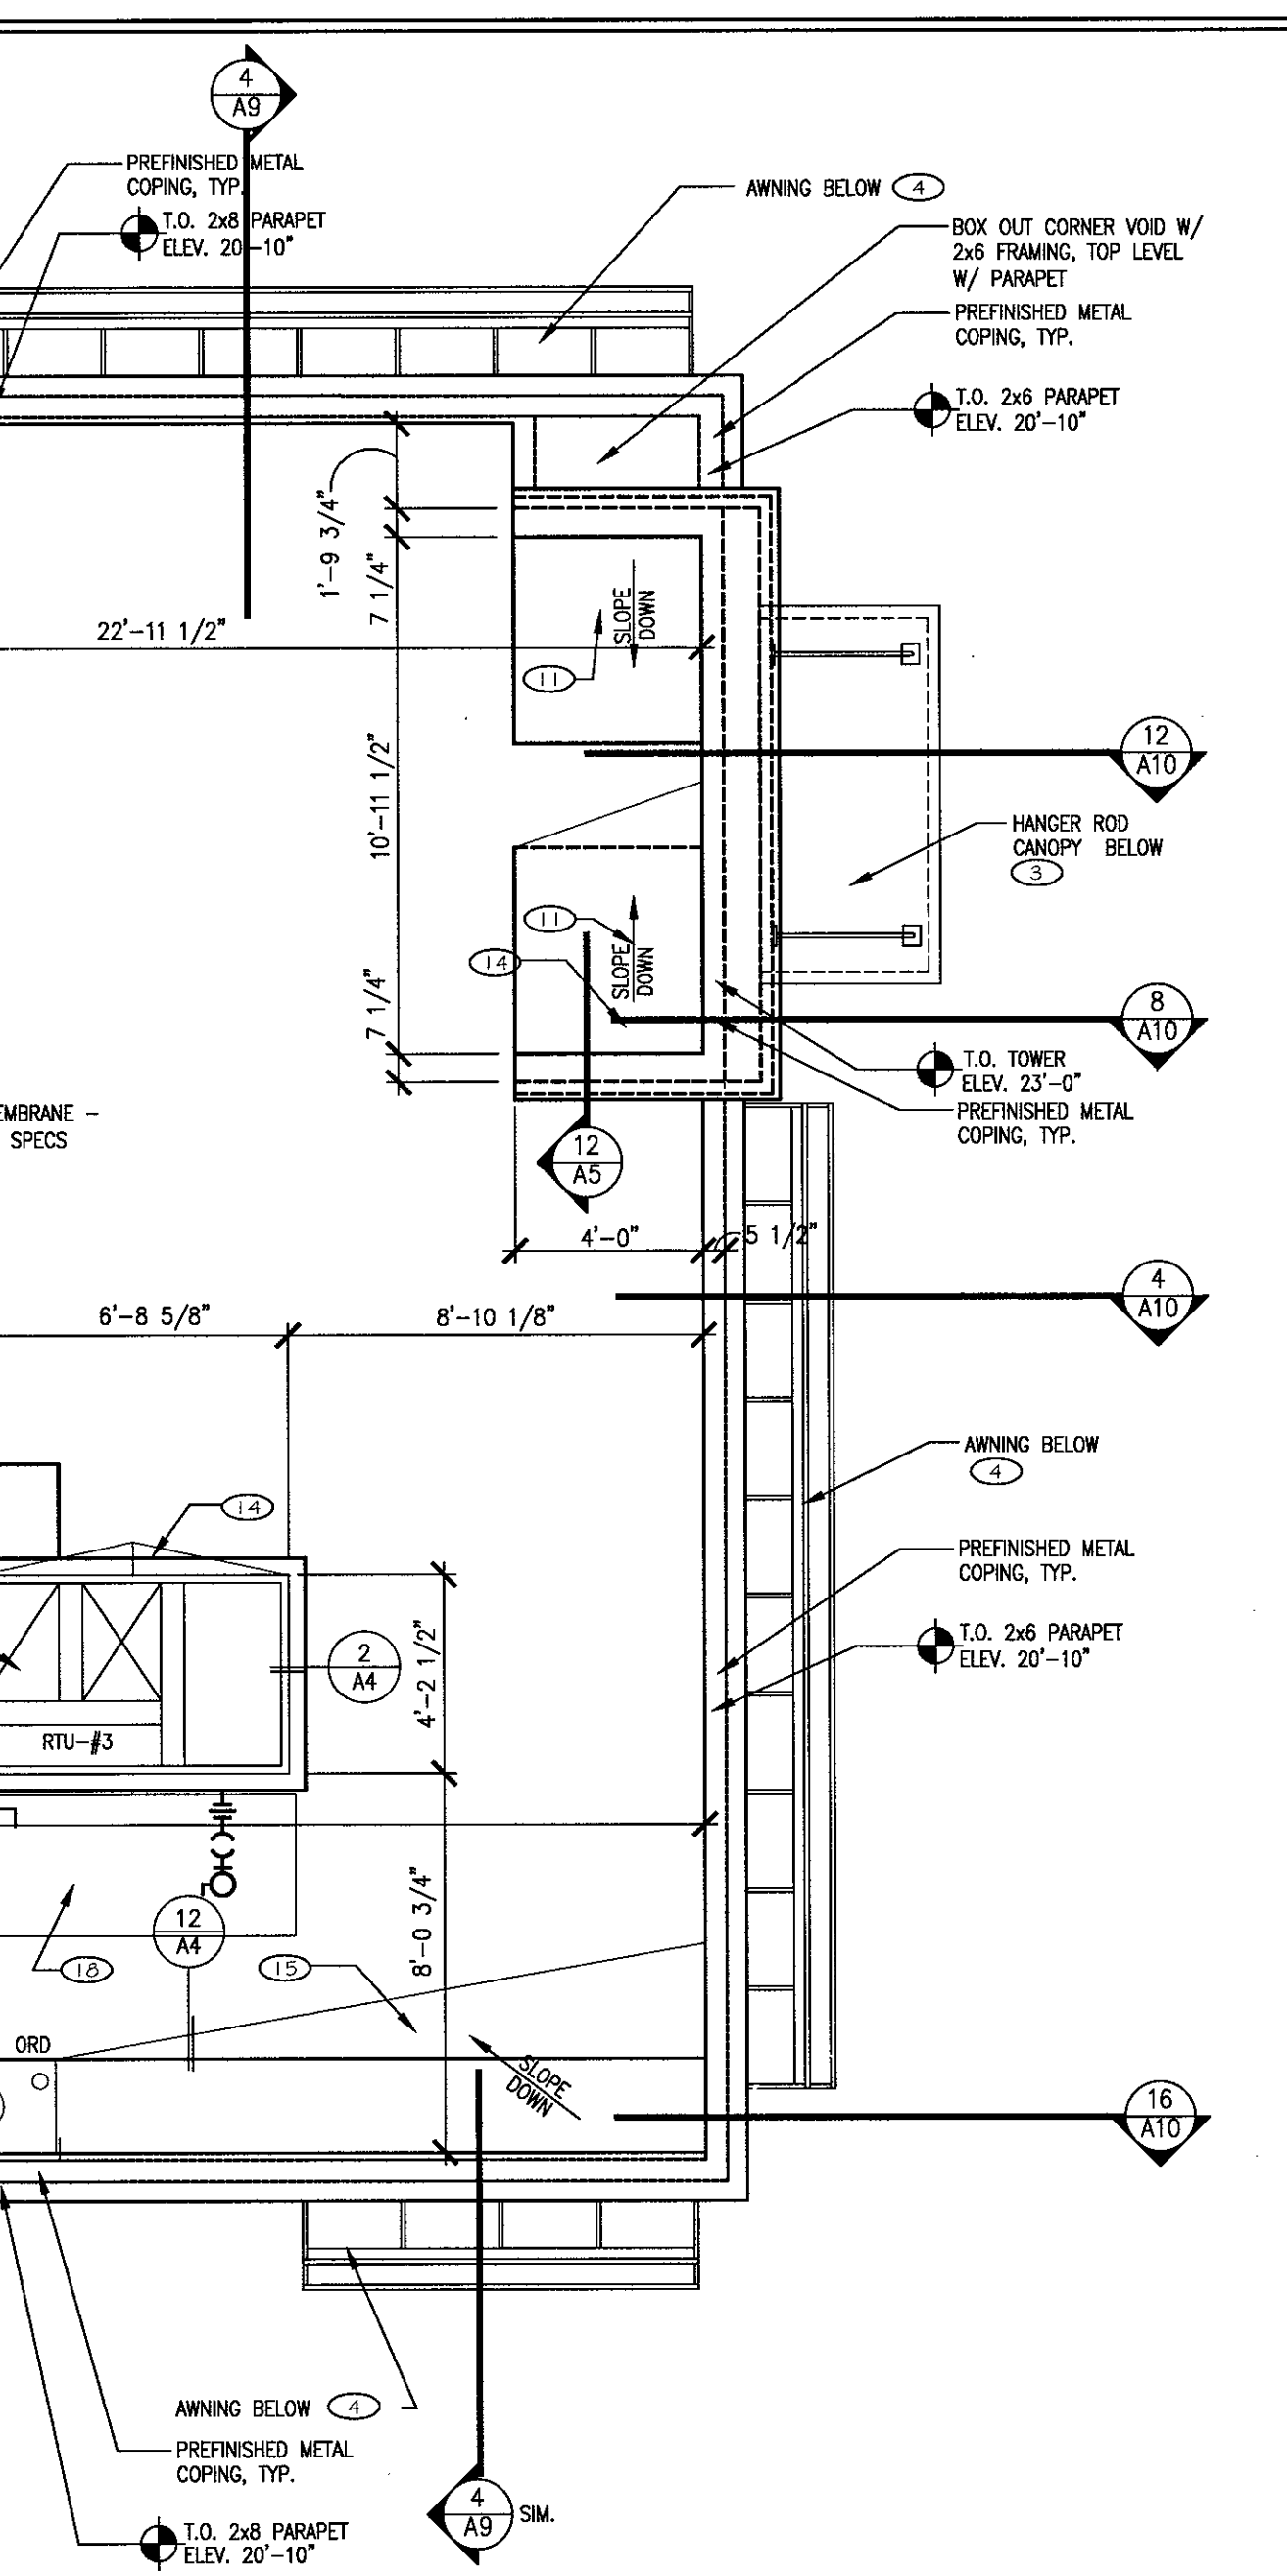


GENERAL ROOF NOTES

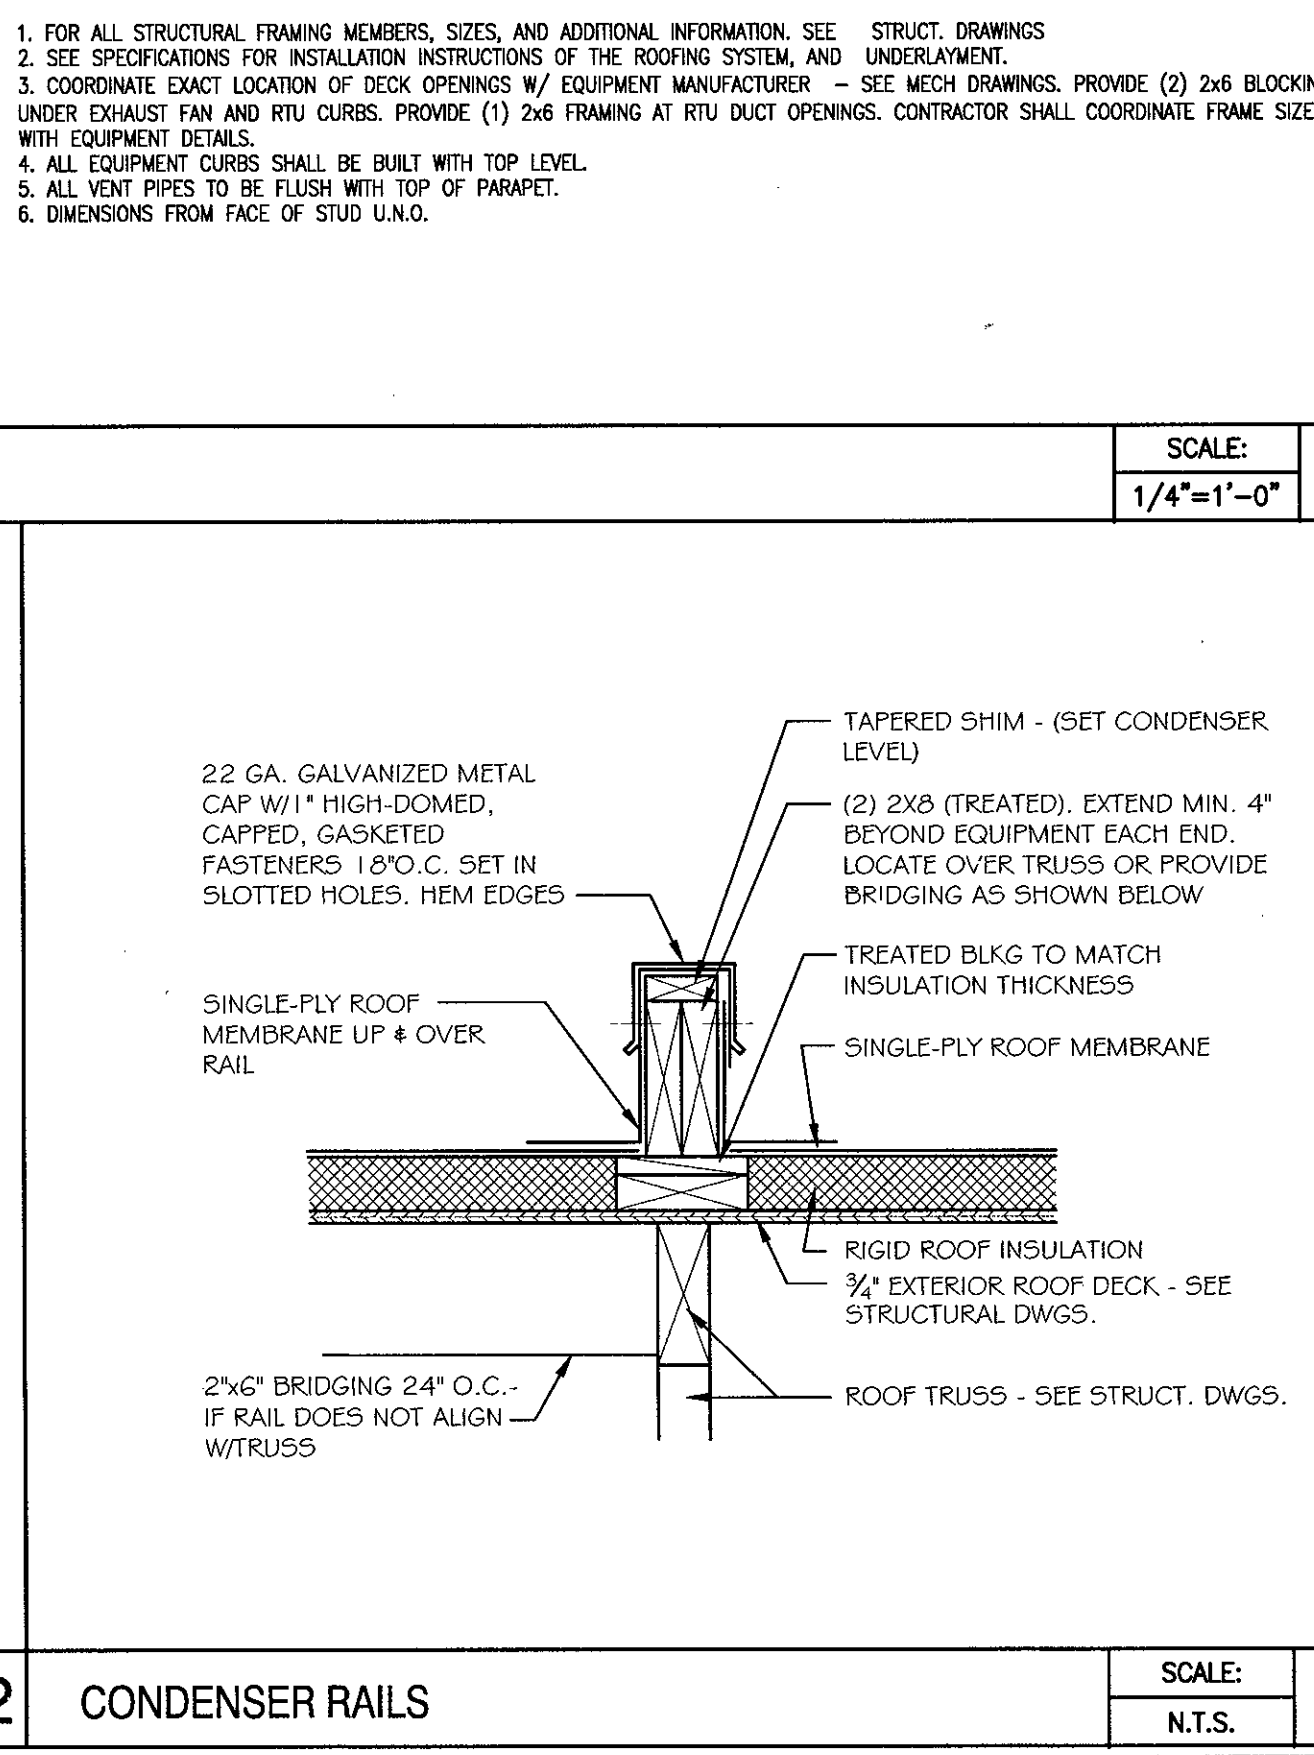


CONDENSER RAILS
SCALE: 8
N.T.S.

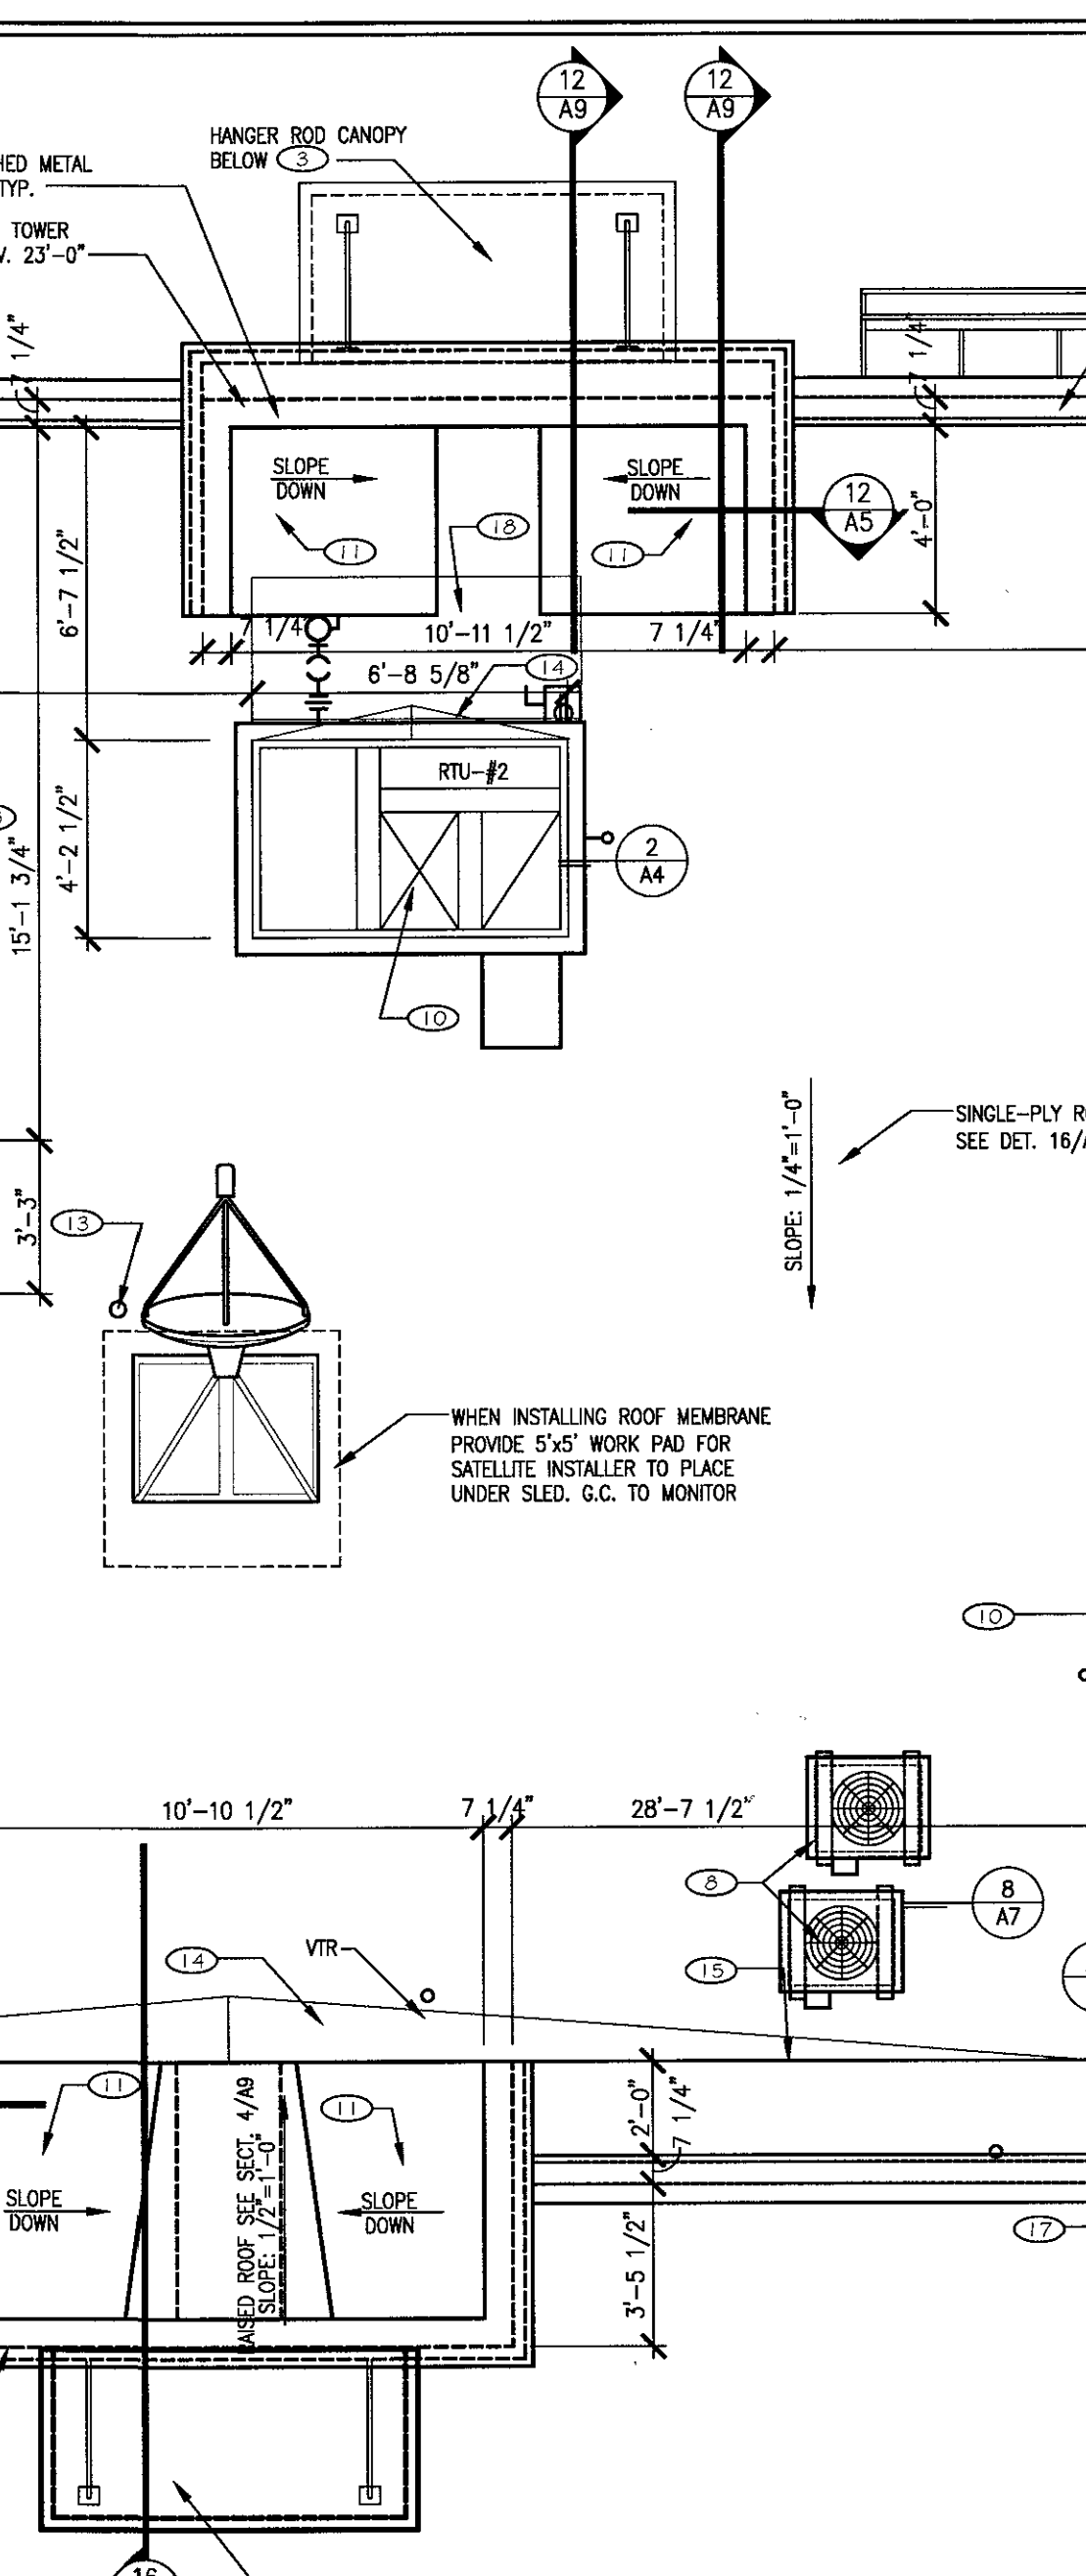


LOW SIDE CRICKET
SCALE: 16
N.T.S.

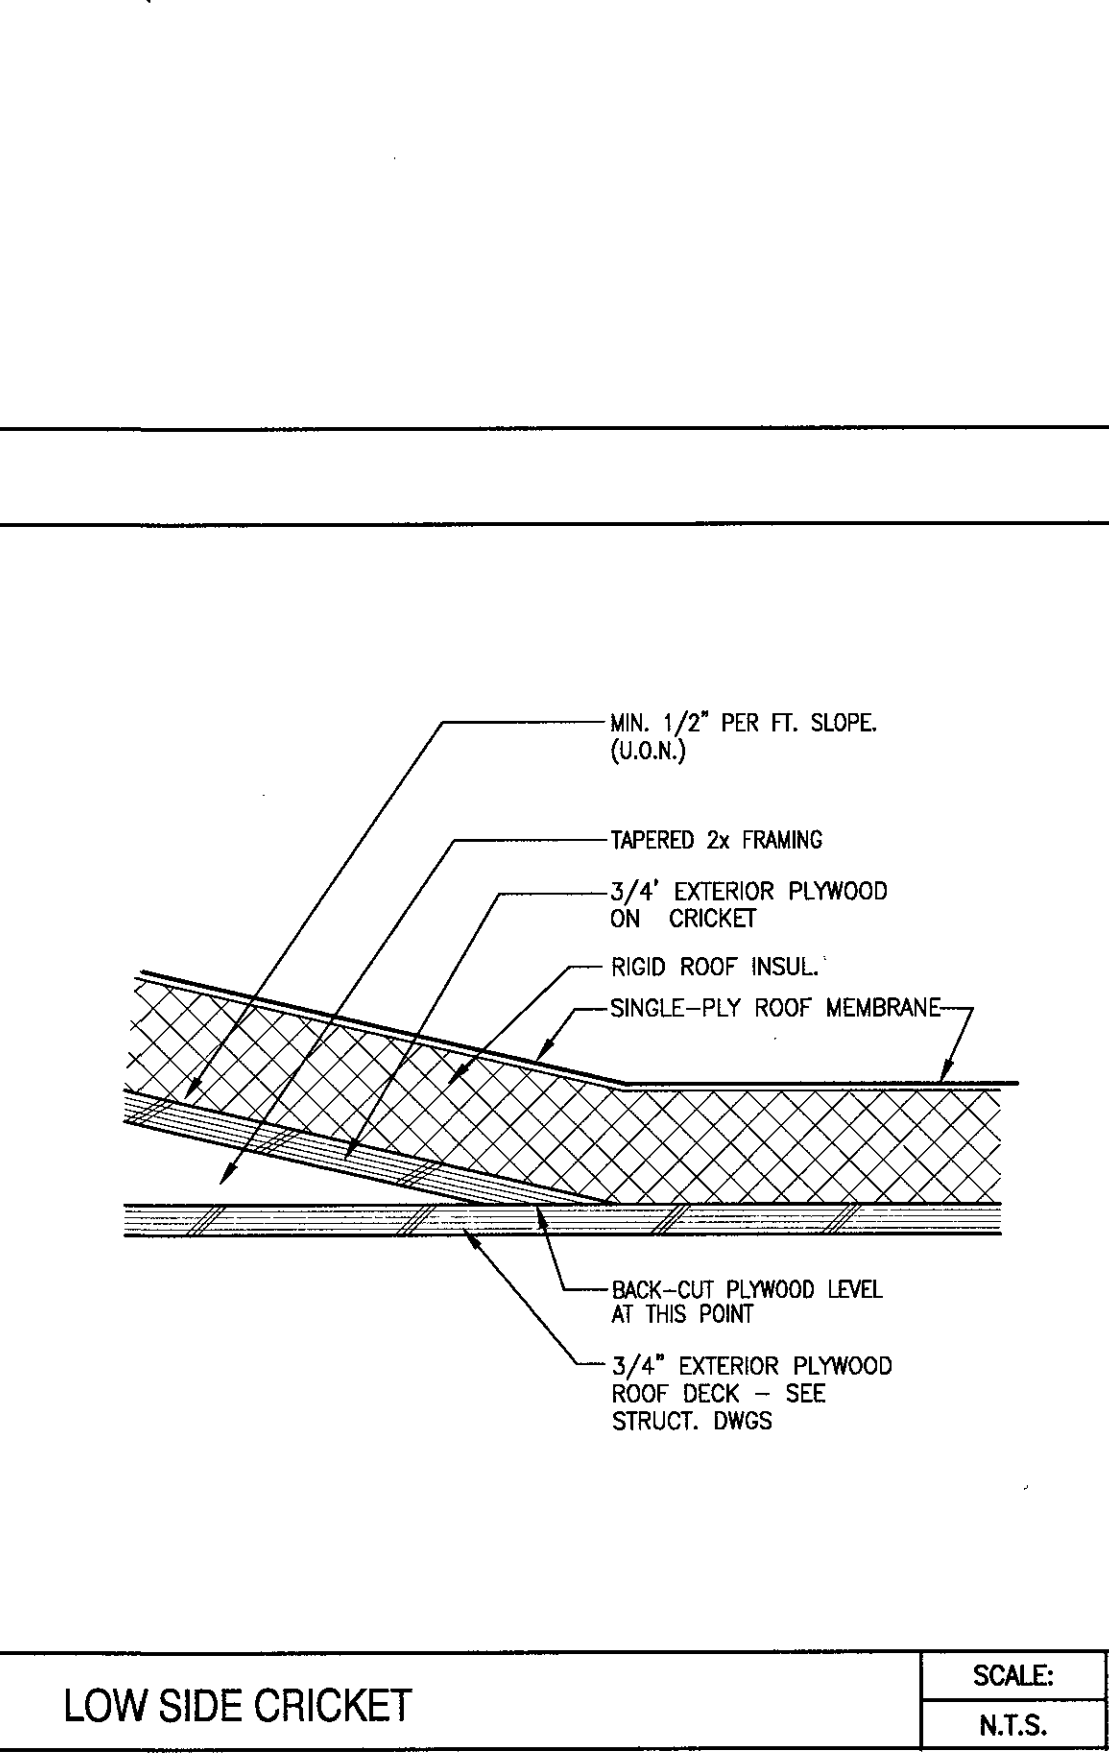

TYPICAL ROOFING
SCALE: 20
N.T.S.

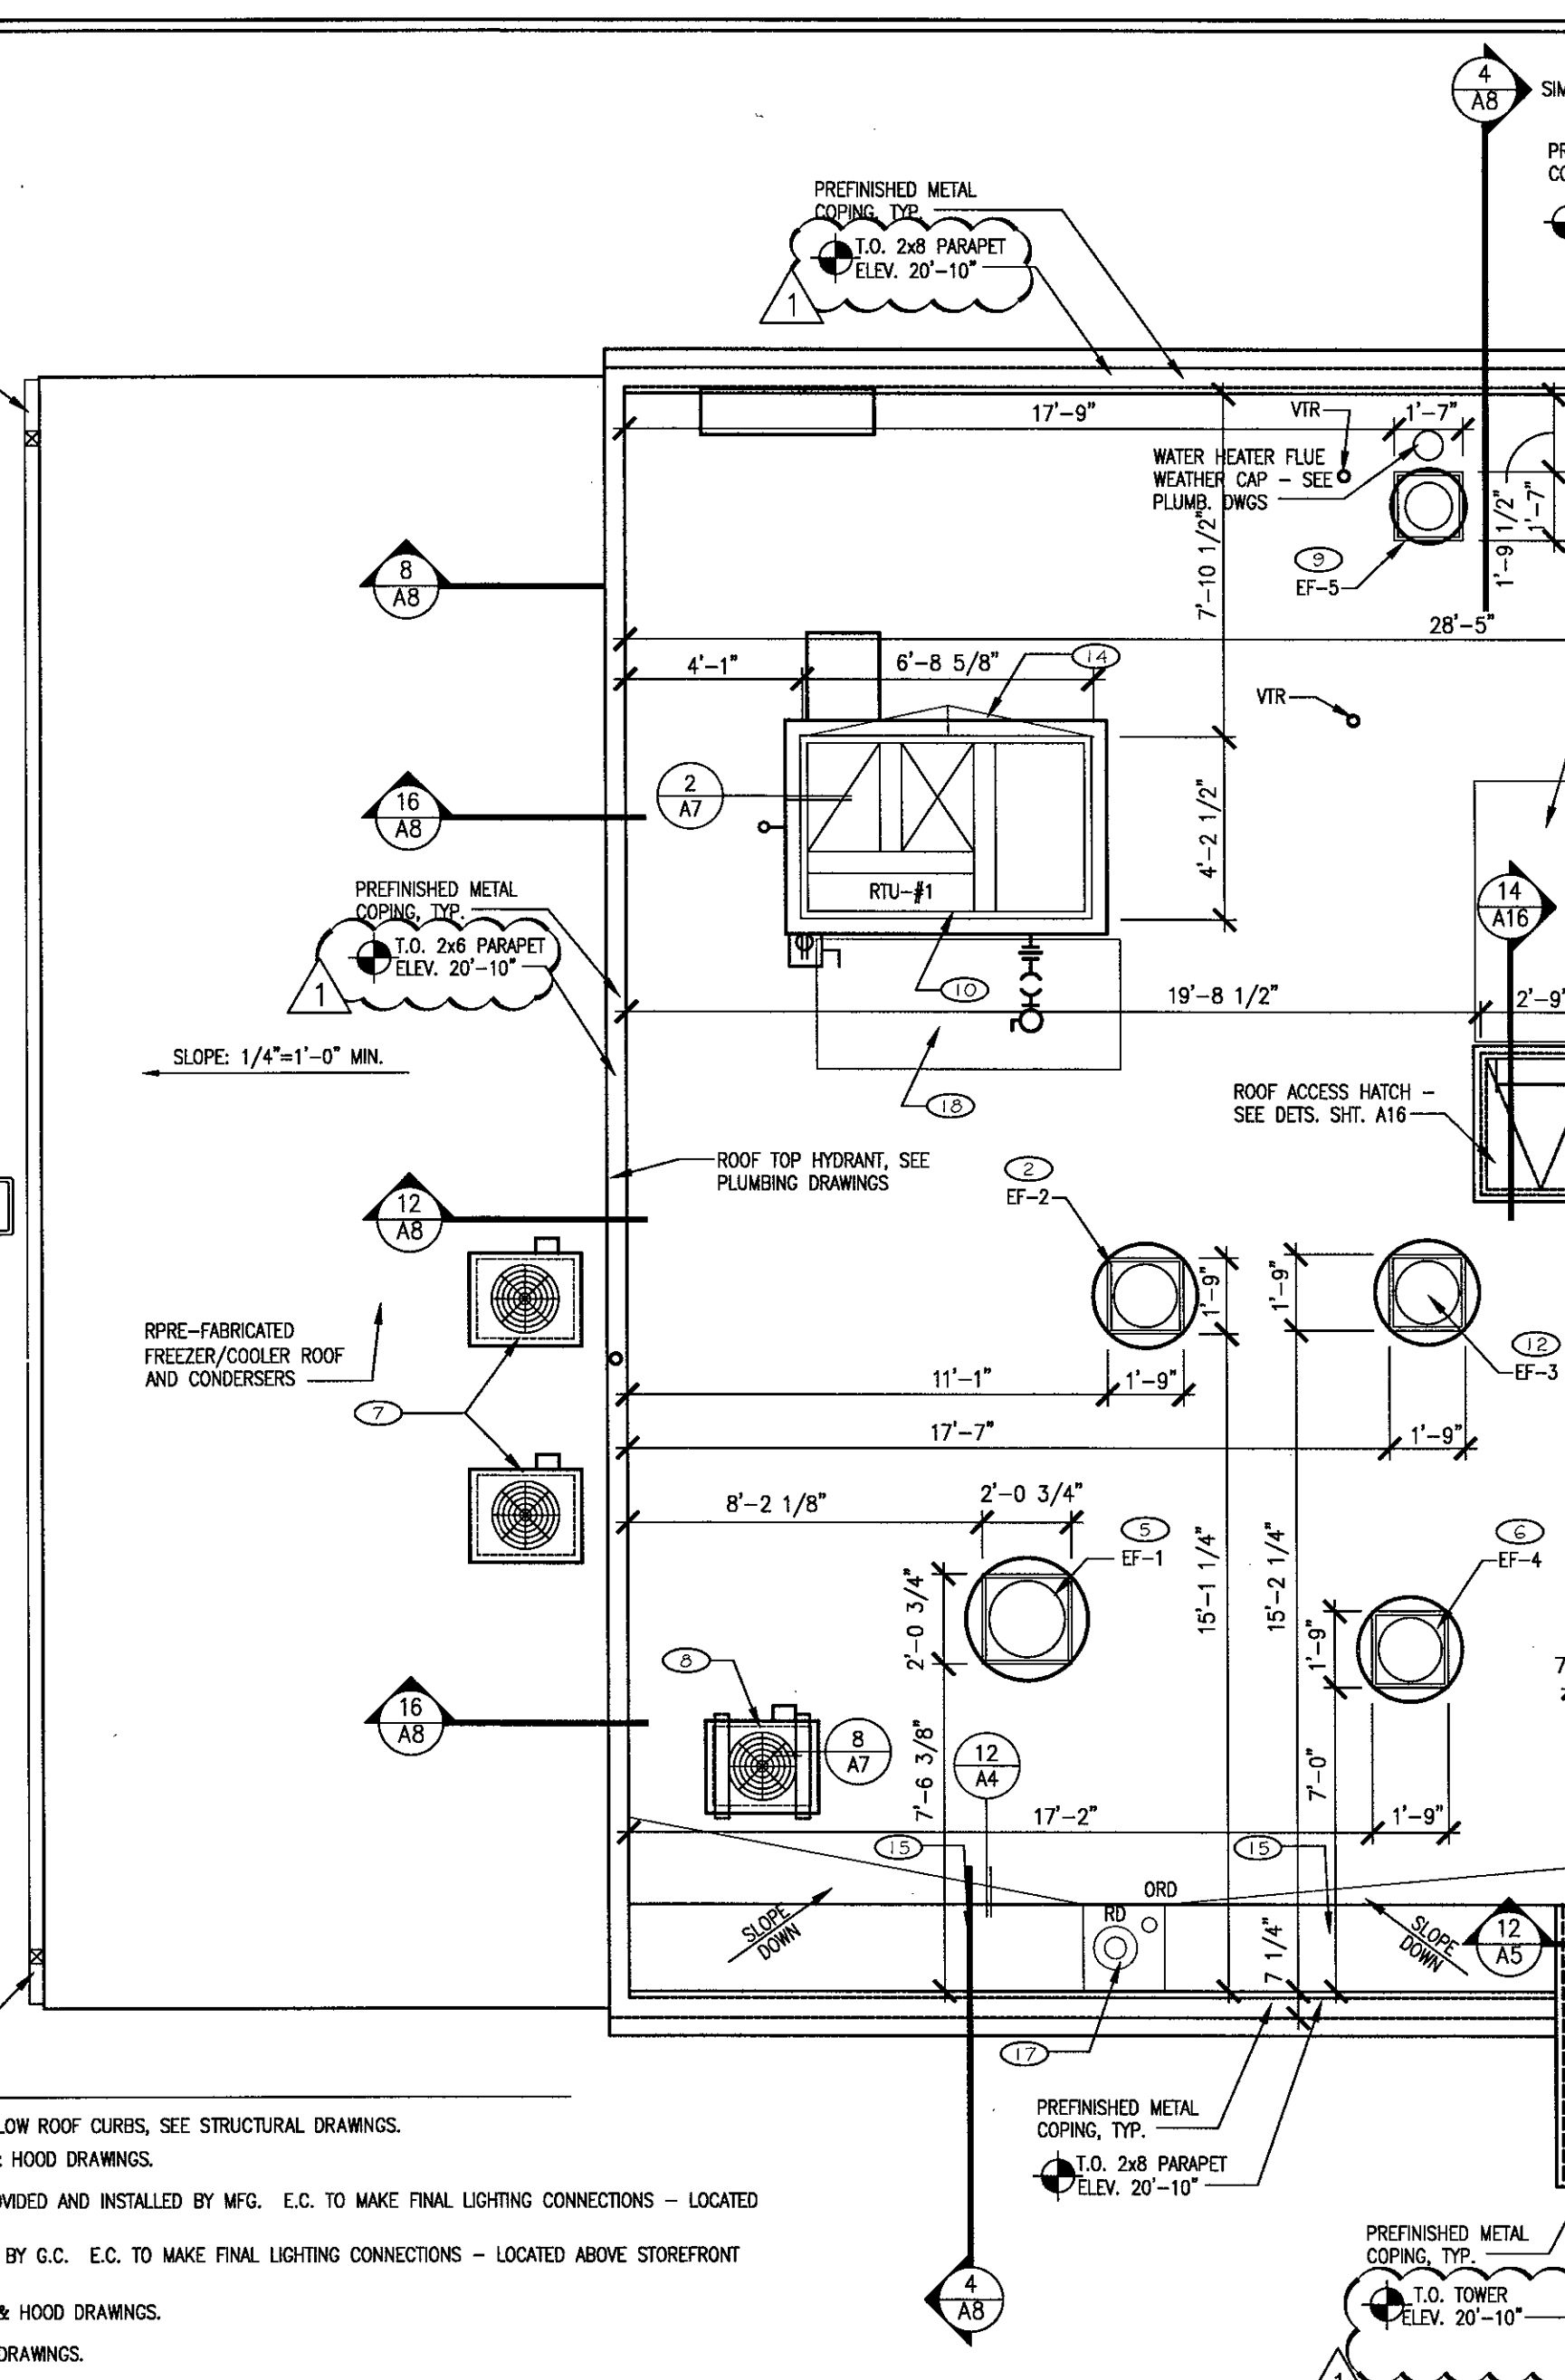

ROOF PLAN
SCALE: 7
1/4"=1'-0"

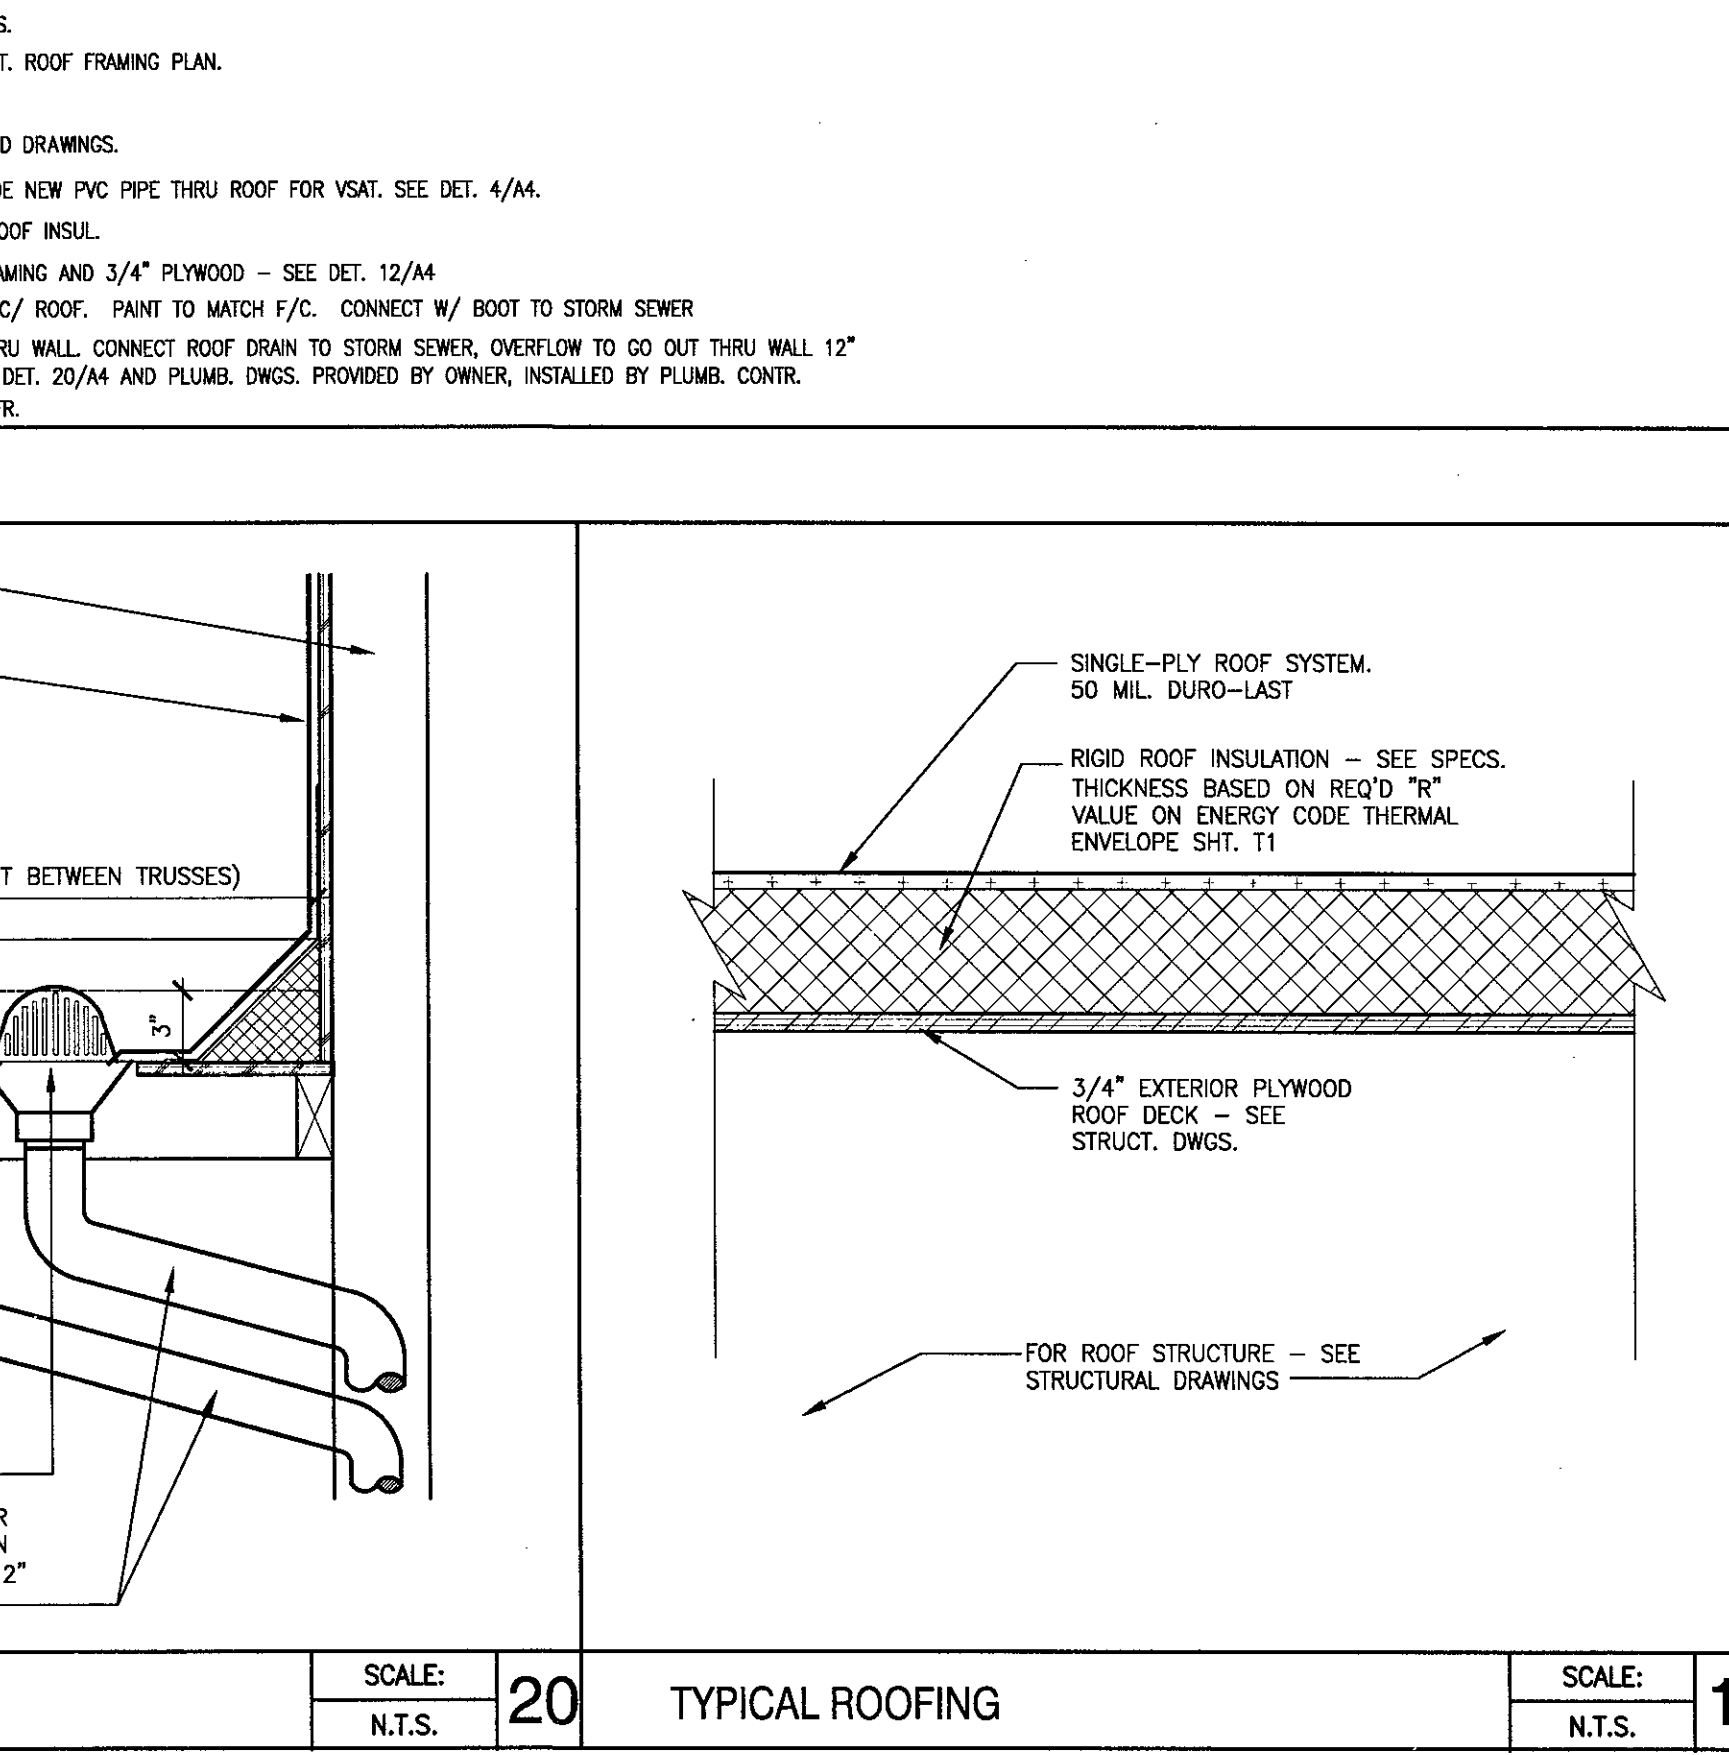

ROOF DRAIN & OVERFLOW
SCALE: 20
N.T.S.

- CONSTRUCTION NOTES**
- PROVIDE BLOCKING AT DUCT OPENINGS & BELOW ROOF CURBS, SEE STRUCTURAL DRAWINGS.
 - BISCUIT OVEN EXHAUST FAN - SEE MECH & HOOD DRAWINGS.
 - STEEL CANOPY W/ SOLID SKINNED TOP - PROVIDED AND INSTALLED BY MFG. E.C. TO MAKE FINAL LIGHTING CONNECTIONS - LOCATED ABOVE ENTRY & DRIVE-THRU.
 - AWNING PROVIDED BY OWNER AND INSTALLED BY G.C. E.C. TO MAKE FINAL LIGHTING CONNECTIONS - LOCATED ABOVE STOREFRONT WINDOWS.
 - CHAIN BROILER EXHAUST FAN - SEE MECH & HOOD DRAWINGS.
 - FRYER EXHAUST FAN - SEE MECH & HOOD DRAWINGS.
 - FREEZER/COOLER CONDENSER UNIT - COORDINATE EXACT LOCATION W/ FREEZER/ COOLER MANUFACTURER.
 - ICE MACHINE CONDENSER - SEE MECH DRAWINGS.
 - TOILET EXHAUST FAN - SEE MECH DRAWINGS.
 - HVAC UNIT - SEE MEP DRAWINGS & STRUCT. ROOF FRAMING PLAN.
 - SLOPED BRACE - SEE DET. 12/A5.
 - GRIDDLE EXHAUST FAN - SEE MECH & HOOD DRAWINGS.
 - PROVIDE CABLE (DOWN TO OFFICE) - PROVIDE NEW PVC PIPE THRU ROOF FOR VENT. SEE DET. 4/M.
 - PROVIDE CRICKET MADE OF TAPERED RIGID ROOF INSUL.
 - PROVIDE CRICKET MADE OF TAPERED 2x4 FRAMING AND 3/4" PLYWOOD - SEE DET. 12/M.
 - PROVIDE GUTTER AND DOWNSPOUTS FROM F/C ROOF. PAINT TO MATCH F/C. CONNECT W/ BOOT TO STORM SEWER.
 - ROOF DRAIN AND OVERFLOW DRAIN THRU WALL. CONNECT ROOF DRAIN TO STORM SEWER, OVERFLOW TO GO OUT THRU WALL 12" ABOVE SLAB W/ DECORATIVE "TONGUE". SEE DET. 20/M AND PLUMB. DWGS. PROVIDED BY OWNER, INSTALLED BY PLUMB. CONTR.
 - PROVIDE WALK PAD PER ROOF MEMBRANE MFR.