


E:\Projects\6078-18\6078-18.dwg 3/10/2023 12:15 PM 6078-18.dwg 3/10/2023 12:15 PM 6078-18.dwg 3/10/2023 12:15 PM 6078-18.dwg 3/10/2023 12:15 PM

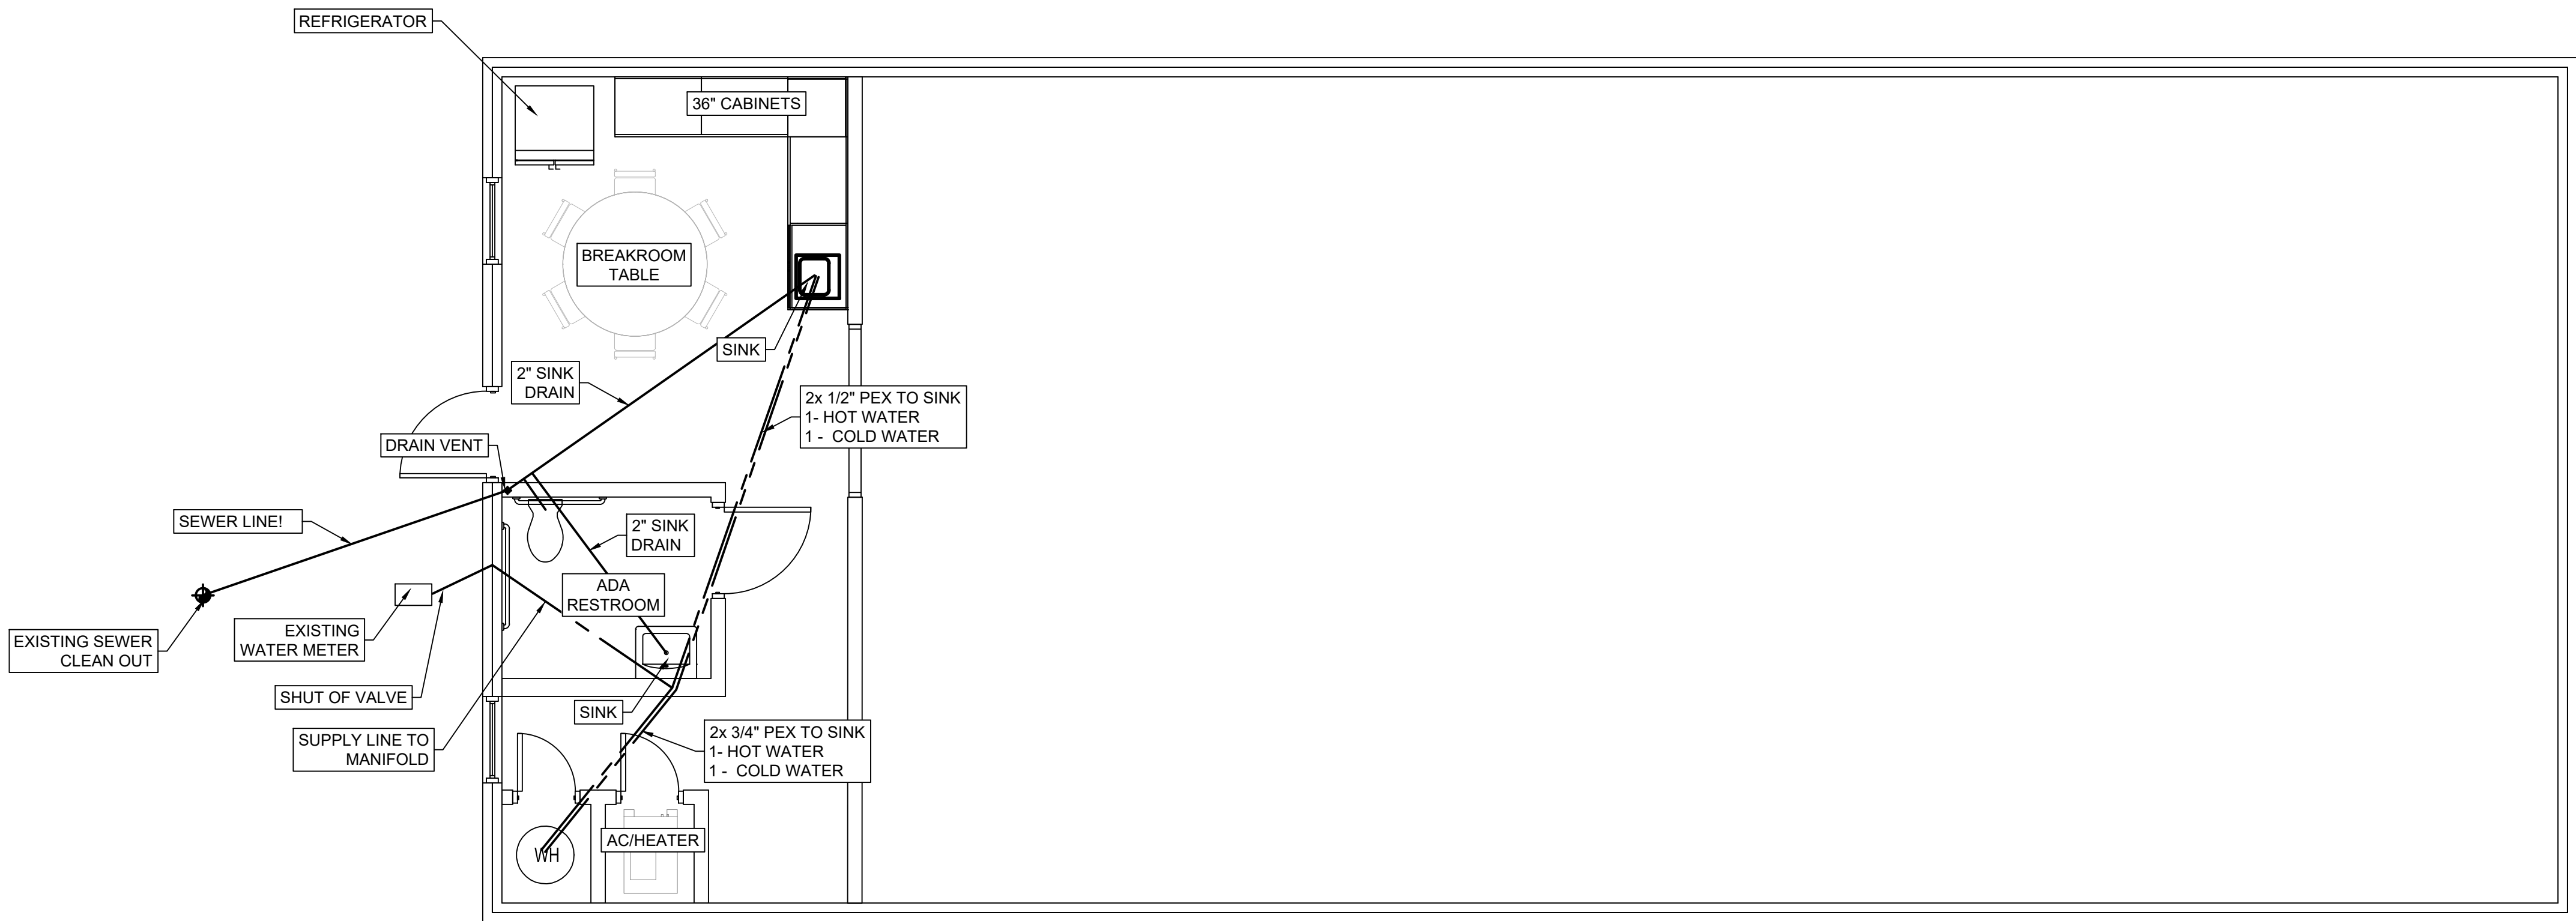

FLOOR PLAN
SCALE 1/4"=1'

- NOTES:
1. INSTALL 1" CUSTOMER CUT OFF VALVE ON EXISTING SERVICE.
 2. PLUMB DRAINS TO EXISTING SEWER LATERAL AND RECONNECT.

THIS DOCUMENT IS RELEASED FOR THE PURPOSE OF INTERIM REVIEW ONLY. IT IS NOT TO BE USED FOR FINAL BIDDING, PERMIT ACQUISITION AND/OR CONSTRUCTION PURPOSES.

2023 BUILDING PROJECT
FLOOR PLAN

NO.	REVISIONS	APPD.	DATE